



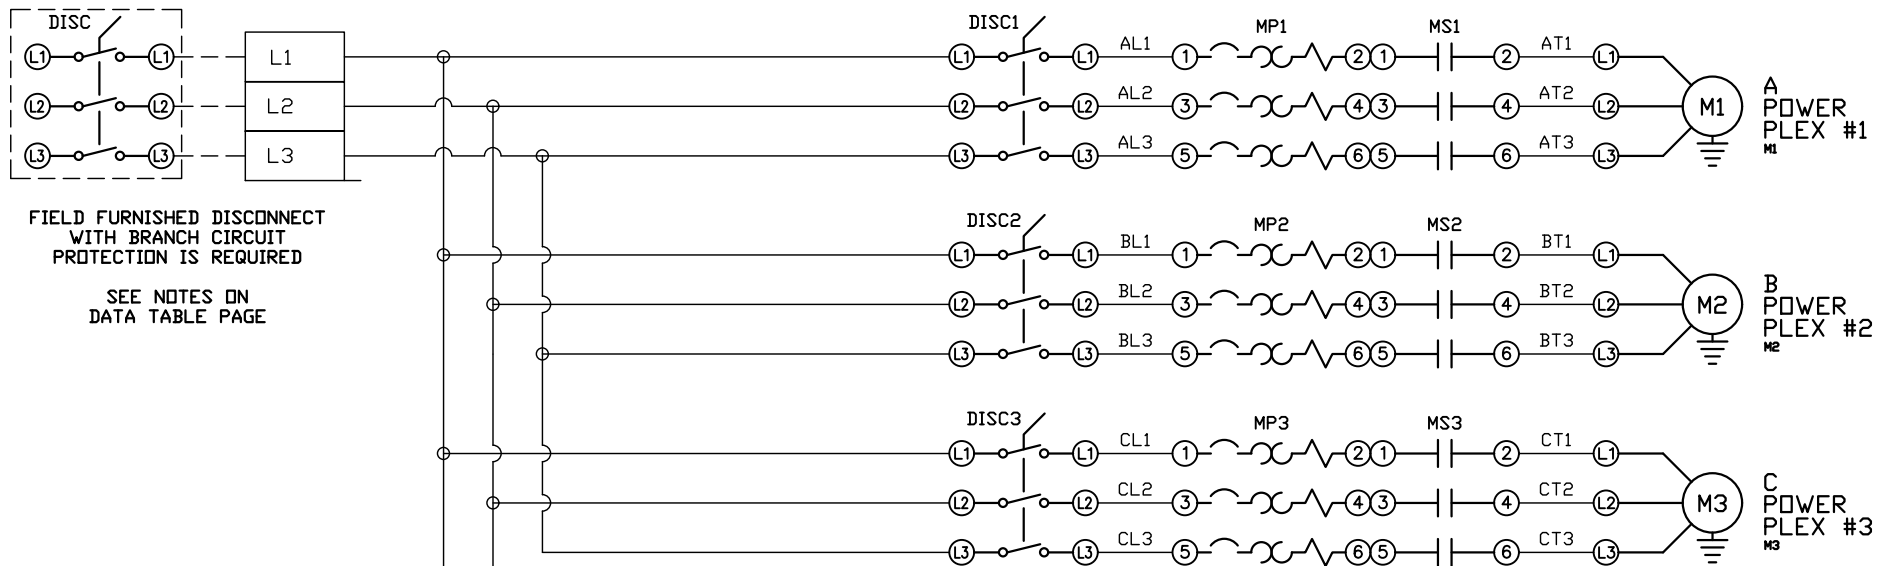

REV	REVISION	DATE	ECN	NAME	CHKD
B-1	RELEASE TO PRODUCTION	10/09/12	22722	BFH	CHR
K-1	ADD CB TO EXTERNAL DEVICES & DISCONNECT TO INPUT POWER	07/17/24	PXEC0628	SEK	JRD
L-1	ADDED GROUND TERMINAL BLOCKS	06/26/25	PXEC0688	JRD	WMM
M-1	PLEX ISOLATION UPDATES	08/28/25	PXEC0639	JNW	WMM

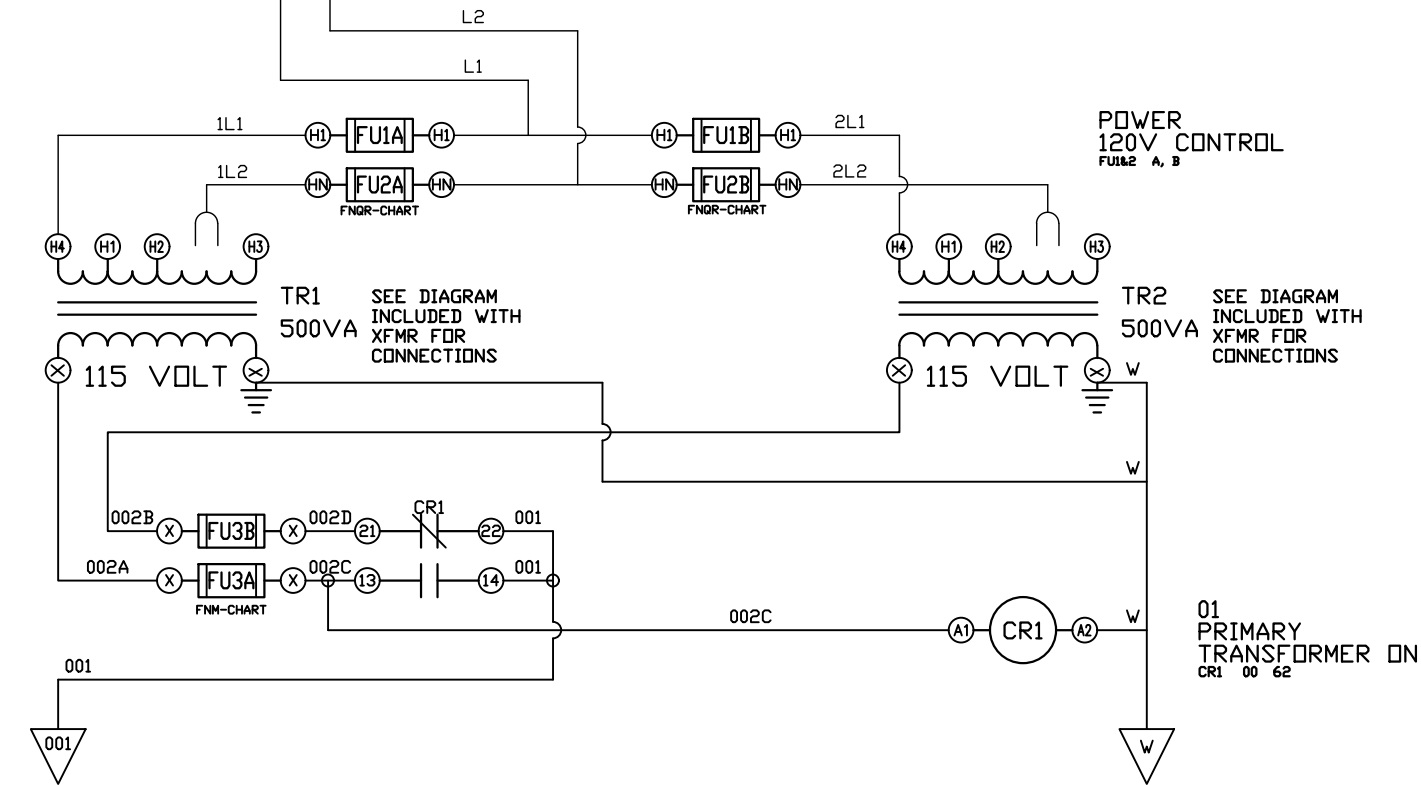

OPTIONAL:

POWEREX™

CONFIDENTIAL DISCLOSURE:
This drawing is the property of POWEREX, INC. of
Marron Specialty Products and is subject to
return on demand. Its contents are confidential
and must not be copied or submitted to outside
parties for use or examination.

DRAWN BY	CHECKED BY	ENGINEERING APPROVAL
BFH	CHR	CHR
10/09/12	10/09/12	10/09/12

PANEL TYPE

LAB VACUUM TRIPLEX

HMI, NFPA

DWG. TYPE WIRING

DWG. NO.

PXMI-VL369

SHEET

W-1

SIZE

B

REV	REVISION	DATE	ECN	NAME	CHKD
B-1	RELEASE TO PRODUCTION	10/09/12	22722	BFH	CHR
K-1	ADD CB TO EXTERNAL DEVICES & DISCONNECT TO INPUT POWER	07/17/24	PXEC0628	SEK	JRD
L-1	ADDED GROUND TERMINAL BLOCKS	06/26/25	PXEC0688	JRD	WMM
M-1	PLEX ISOLATION UPDATES	08/28/25	PXEC0639	JNW	WMM

OPTIONAL:

POWEREX™

CONFIDENTIAL DISCLOSURE:
This drawing is the property of POWEREX, INC. of
Marmion Specialty Products and is subject to
return on demand. Its contents are confidential
and must not be copied or submitted to outside
parties for use or examination.

DRAWN BY	CHECKED BY	ENGINEERING APPROVAL
BFH	CHR	CHR
10/09/12	10/09/12	10/09/12

PANEL TYPE

LAB VACUUM TRIPLEX
HMI, NFPA



DWG. TYPE WIRING

DWG. NO.


PXMI-VL369

SHEET	SIZE
W-3	B

* FOR GV4 MOTOR PROTECTORS USE PINS
#1 AND #4 ON AUX CONTACT IN '0F1' SLOT

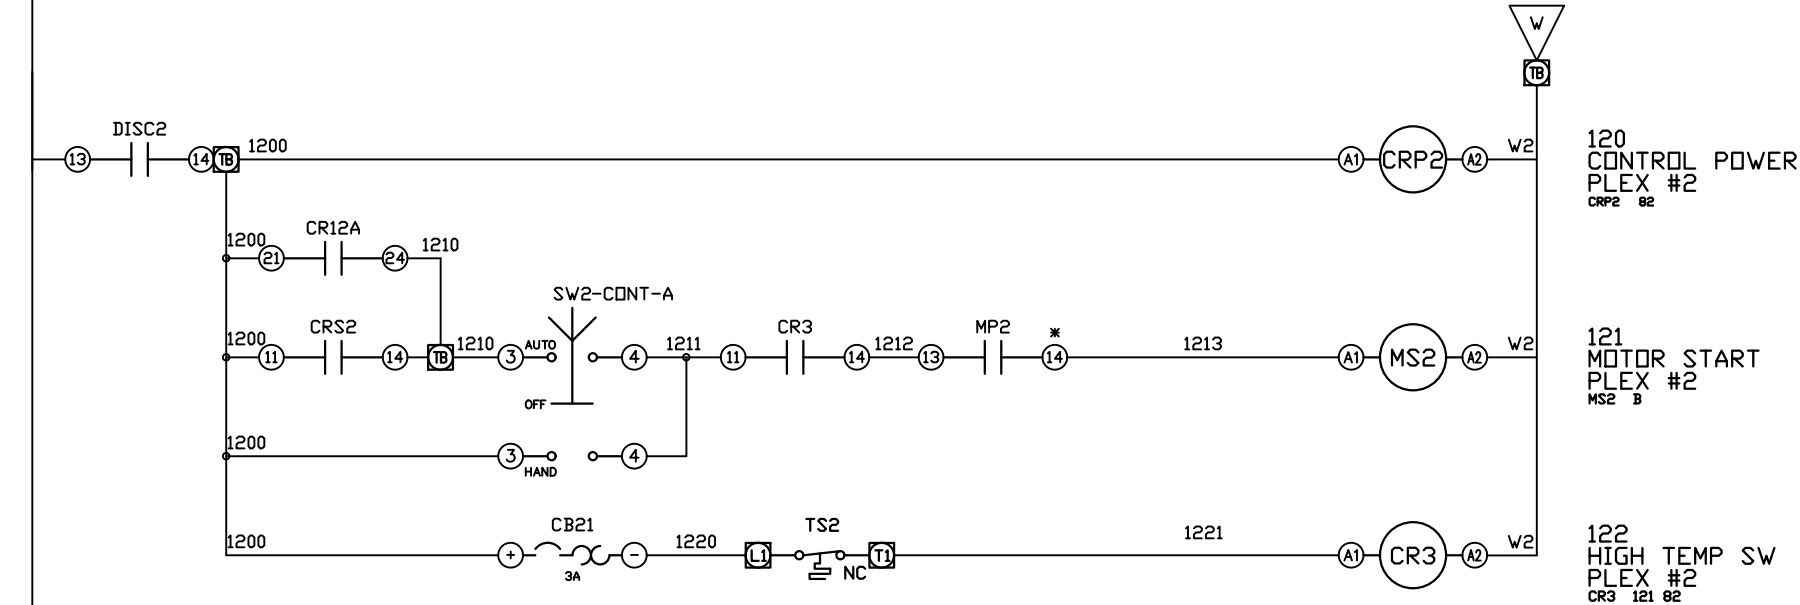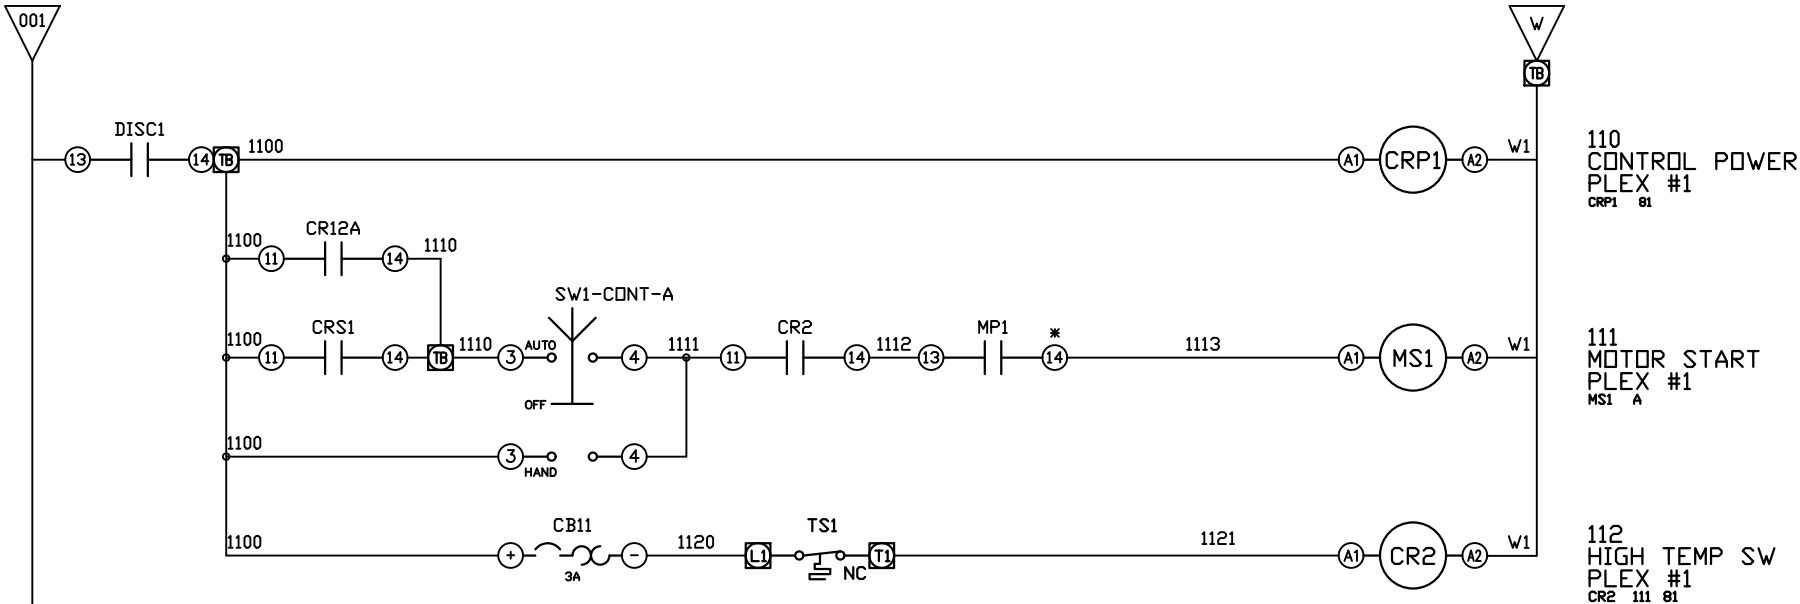

REV	REVISION	DATE	ECN	NAME	CHKD
B-1	RELEASE TO PRODUCTION	10/09/12	22722	BFH	CHR
K-1	ADD CB TO EXTERNAL DEVICES & DISCONNECT TO INPUT POWER	07/17/24	PXEC0628	SEK	JRD
L-1	ADDED GROUND TERMINAL BLOCKS	06/26/25	PXEC0688	JRD	WMM
M-1	PLEX ISOLATION UPDATES	08/28/25	PXEC0639	JNW	WMM

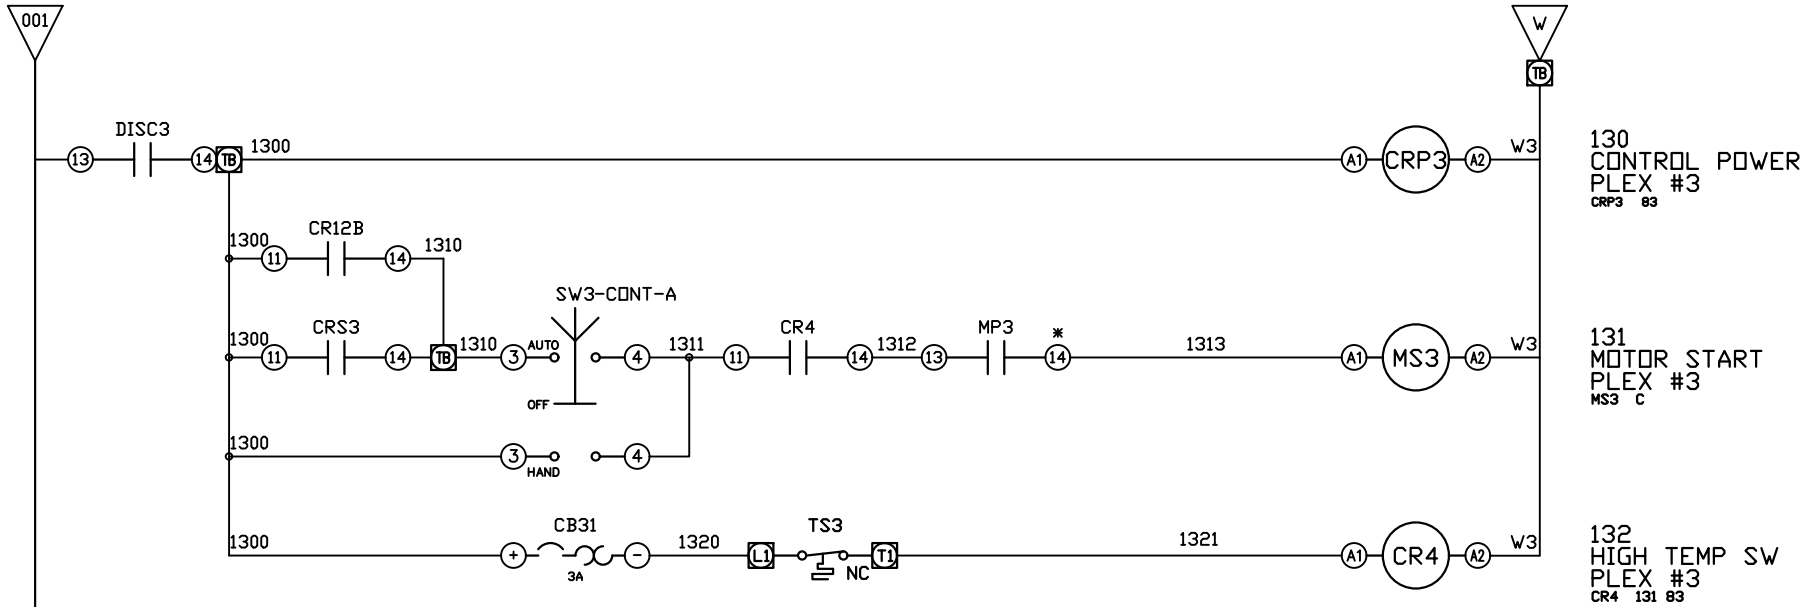

OPTIONAL:

POWEREX™

CONFIDENTIAL DISCLOSURE:
This drawing is the property of POWEREX, INC. of
Marnon Specialty Products and is subject to
return on demand. Its contents are confidential
and must not be copied or submitted to outside
parties for use or examination.

DRAWN BY	CHECKED BY	ENGINEERING APPROVAL
BFH	CHR	CHR
10/09/12	10/09/12	10/09/12

PANEL TYPE

LAB VACUUM TRIPLEX
HMI, NFPA

DWG. TYPE WIRING



DWG. NO.

PXMI-VL369

SHEET	SIZE
W-4	B

* FOR GV4 MOTOR PROTECTORS USE PINS
#1 AND #4 ON AUX CONTACT IN '0F1' SLOT

REV	REVISION	DATE	ECN	NAME	CHKD
B-1	RELEASE TO PRODUCTION	10/09/12	22722	BFH	CHR
K-1	ADD CB TO EXTERNAL DEVICES & DISCONNECT TO INPUT POWER	07/17/24	PXEC0628	SEK	JRD
L-1	ADDED GROUND TERMINAL BLOCKS	06/26/25	PXEC0688	JRD	WMM
M-1	PLEX ISOLATION UPDATES	08/28/25	PXEC0639	JNW	WMM

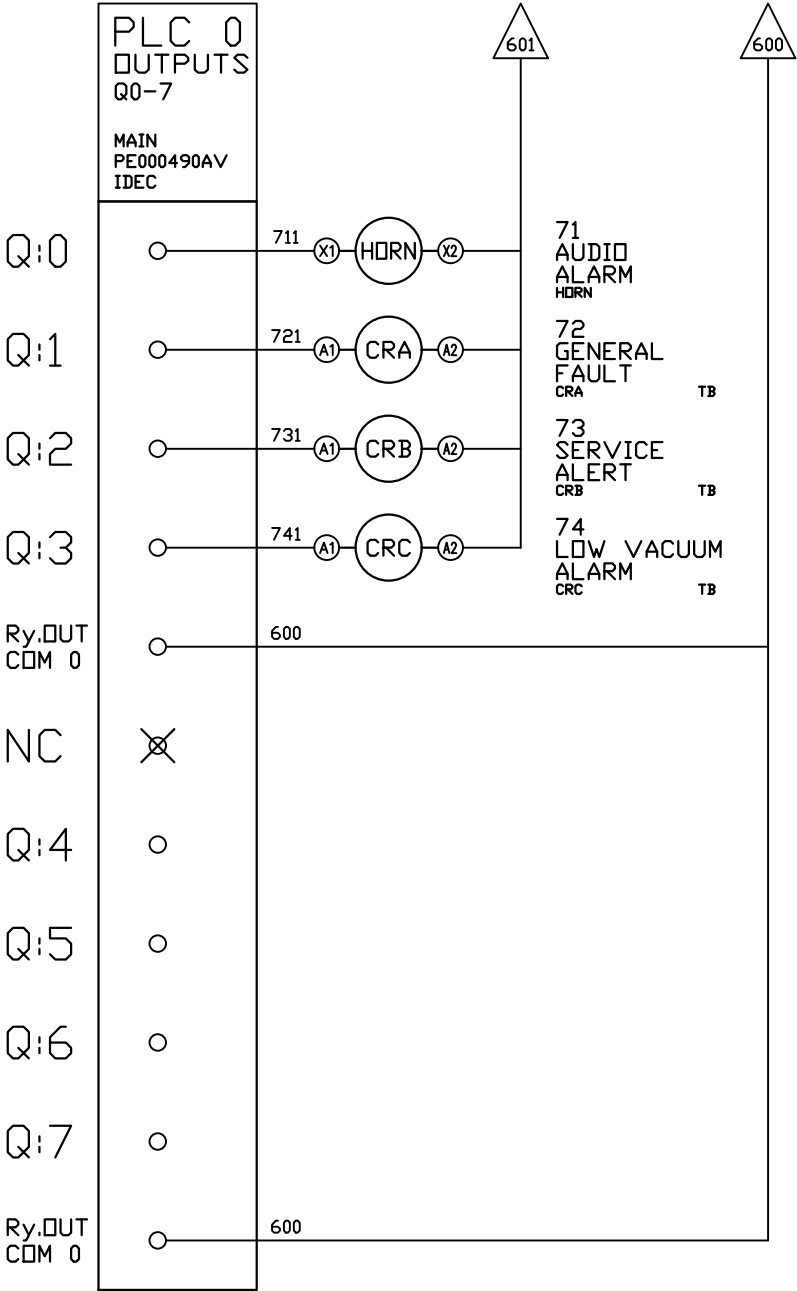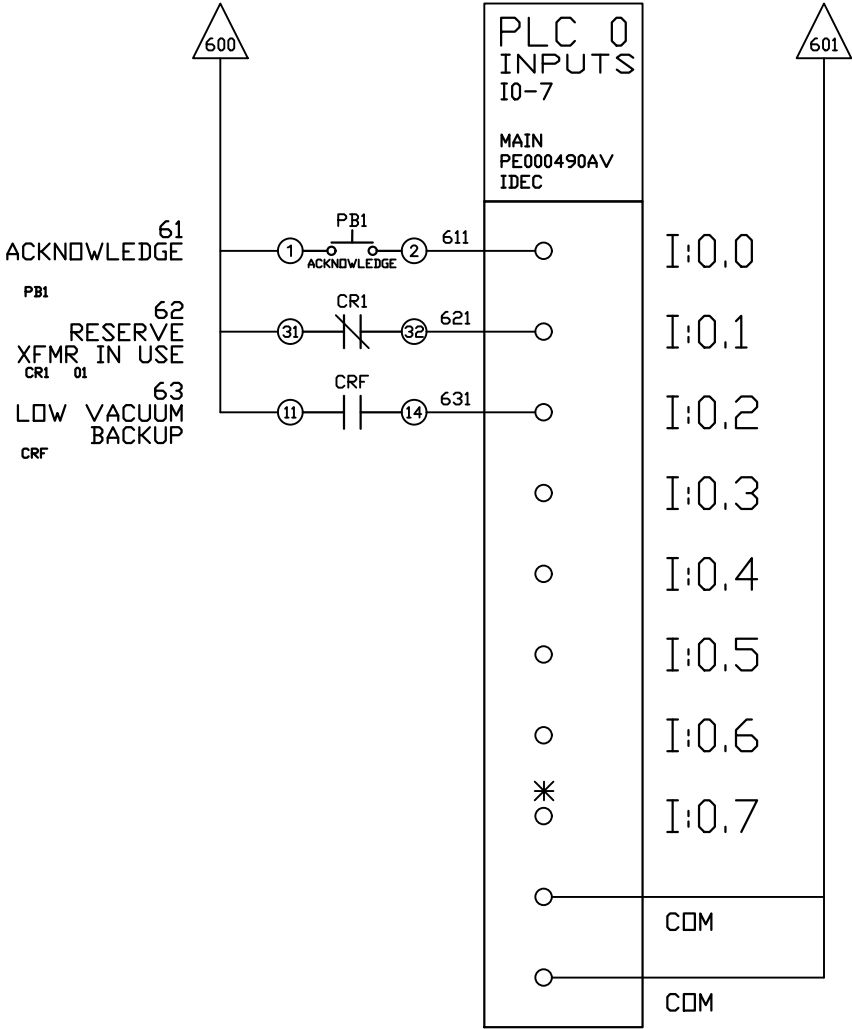

OPTIONAL:

CONFIDENTIAL DISCLOSURE:
This drawing is the property of POWEREX, INC. of
Marnon Specialty Products and is subject to
return on demand. Its contents are confidential
and must not be copied or submitted to outside
parties for use or examination.

DRAWN BY	CHECKED BY	ENGINEERING APPROVAL
BFH	CHR	CHR
10/09/12	10/09/12	10/09/12

PANEL TYPE

LAB VACUUM TRIPLEX
HMI, NFPA

DWG. TYPE WIRING


DWG. NO.

PXMI-VL369

SHEET	SIZE
W-6	B

PXMI-VL369

*FACTORY TEST JUMPER LOCATION

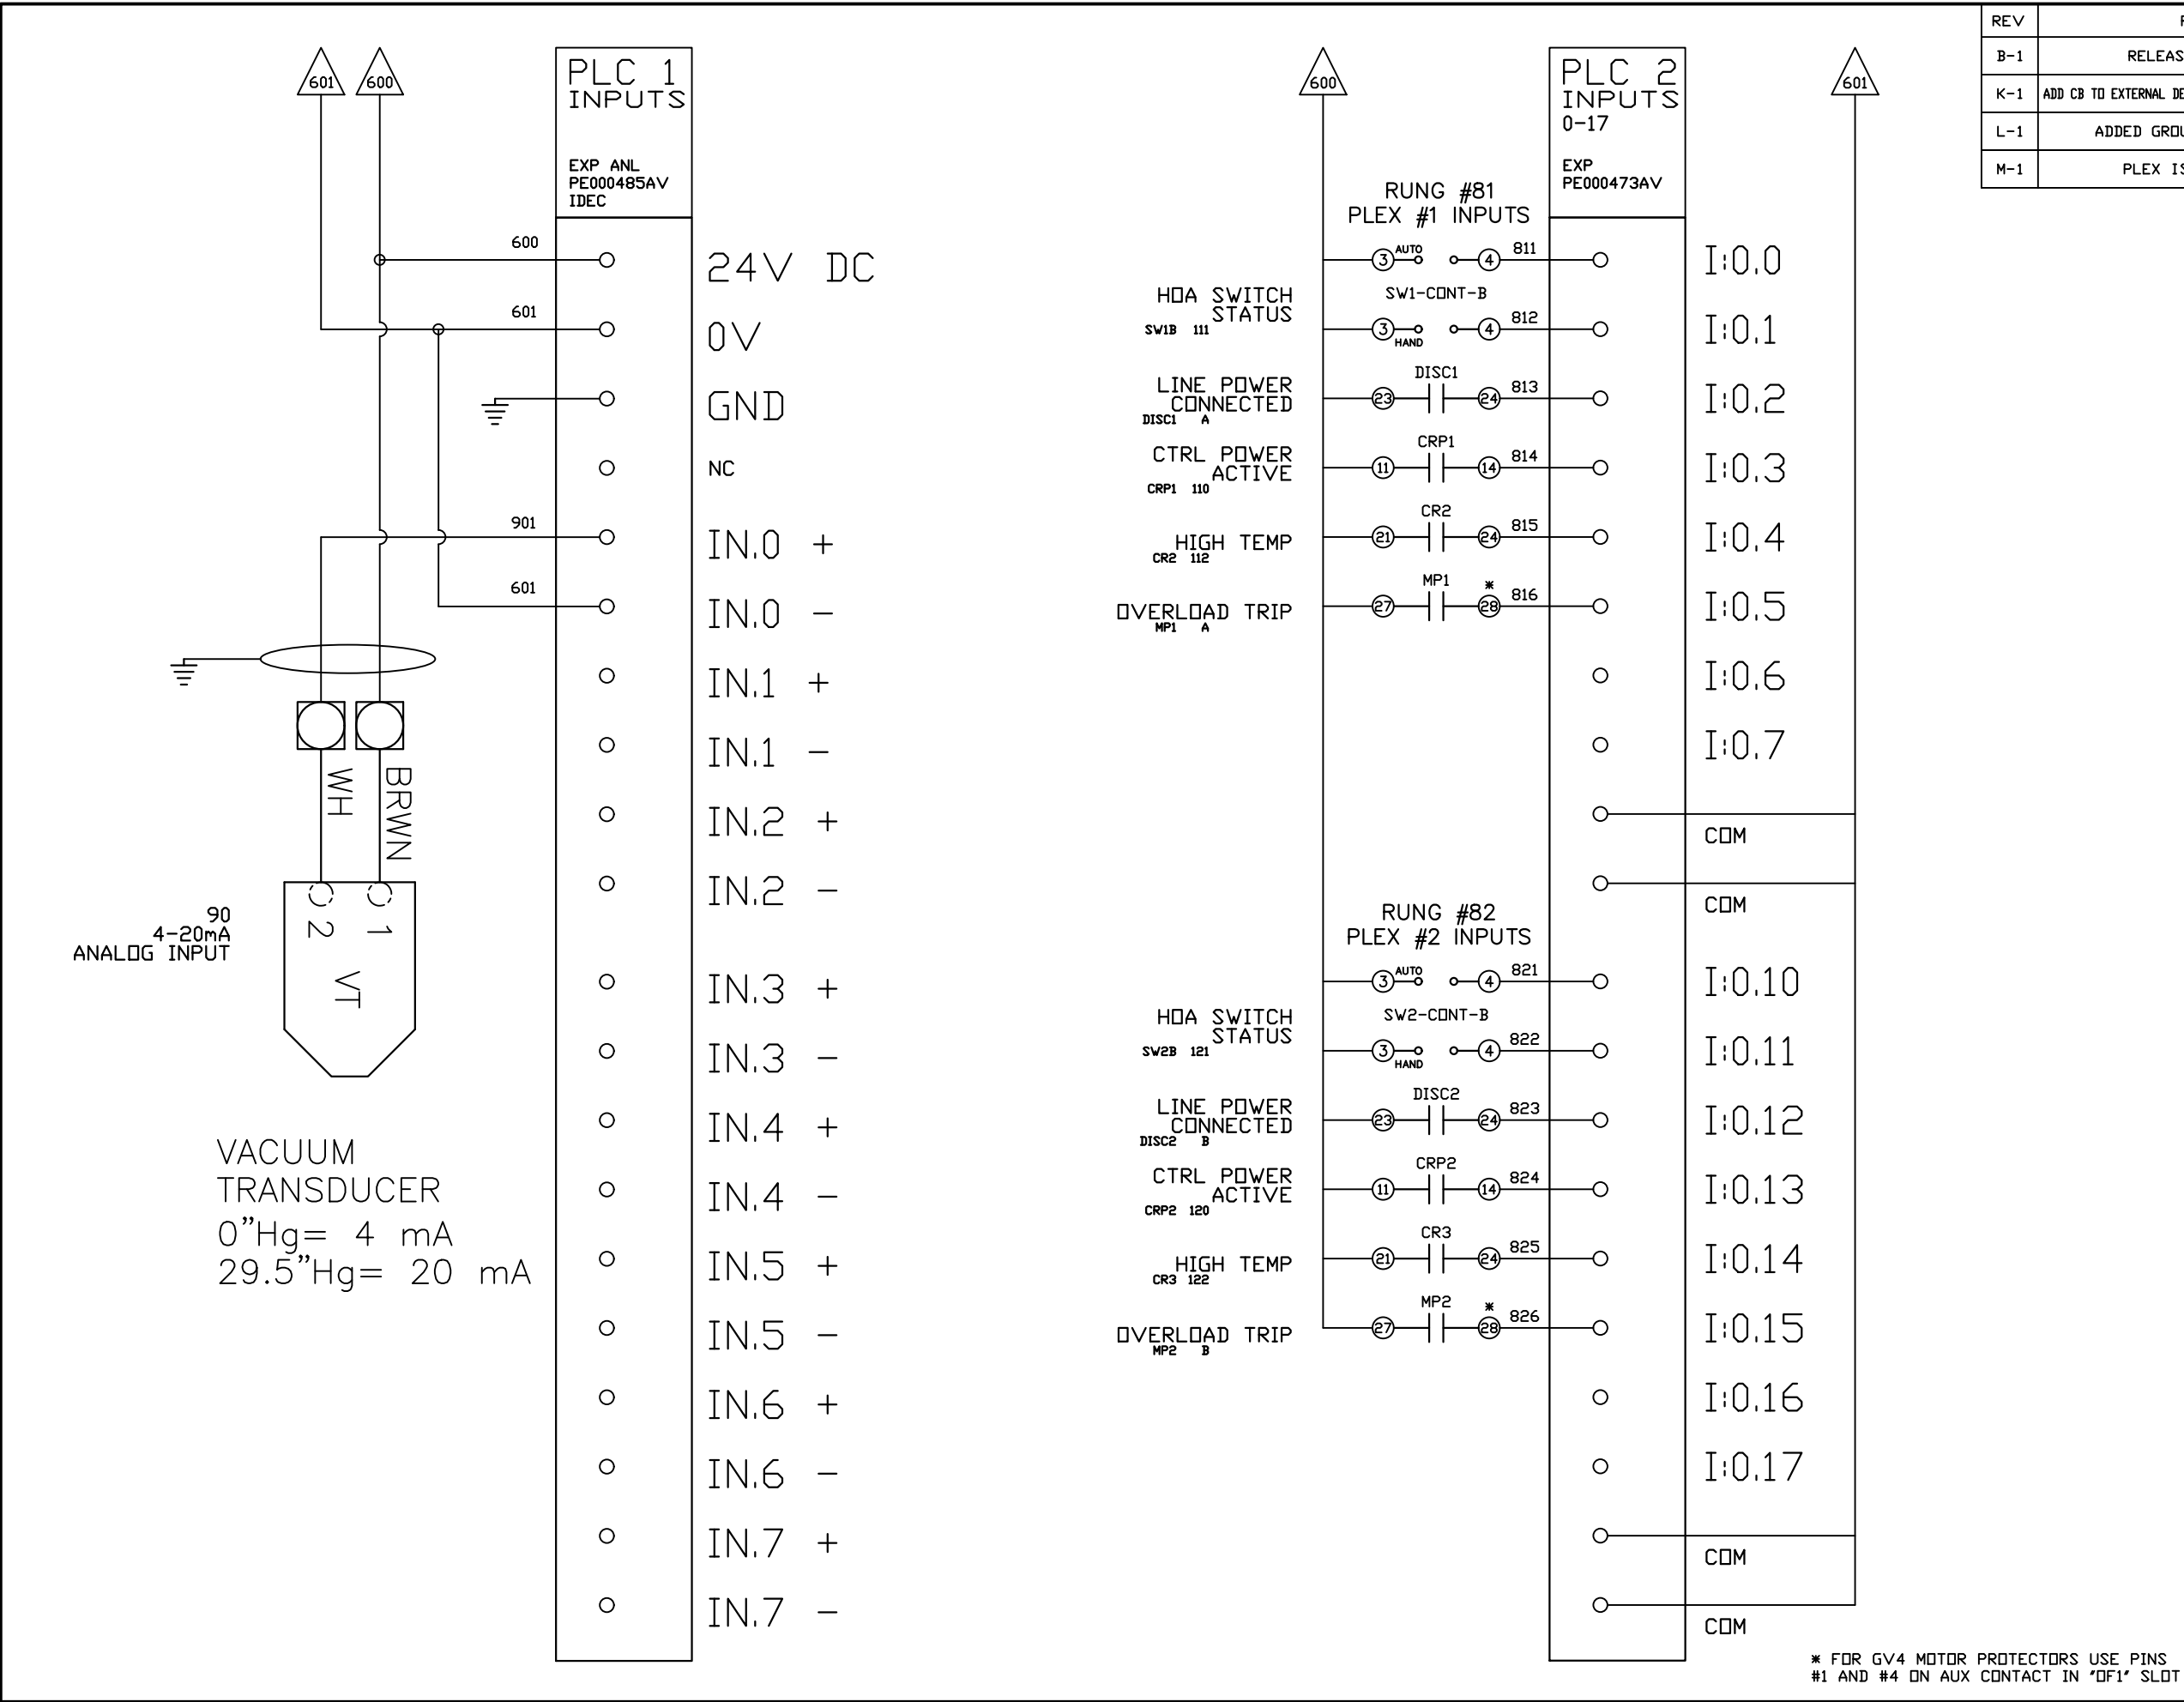

REV	REVISION	DATE	ECN	NAME	CHKD
B-1	RELEASE TO PRODUCTION	10/09/12	22722	BFH	CHR
K-1	ADD CB TO EXTERNAL DEVICES & DISCONNECT TO INPUT POWER	07/17/24	PXEC0628	SEK	JRD
L-1	ADDED GROUND TERMINAL BLOCKS	06/26/25	PXEC0688	JRD	WMM
M-1	PLEX ISOLATION UPDATES	08/28/25	PXEC0639	JNW	WMM

OPTIONAL:

POWEREX™

CONFIDENTIAL DISCLOSURE:
This drawing is the property of POWEREX, INC. of
Marron Specialty Products and is subject to
return on demand. Its contents are confidential
and must not be copied or submitted to outside
parties for use or examination.

DRAWN BY	CHECKED BY	ENGINEERING APPROVAL
BFH	CHR	CHR
10/09/12	10/09/12	10/09/12

PANEL TYPE

LAB VACUUM TRIPLEX
HMI, NFPA

DWG. TYPE WIRING


DWG. NO.


PXMI-VL369

SHEET	SIZE
W-7	B

PXMI-VL369


* FOR GV4 MOTOR PROTECTORS USE PINS #1 AND #4 ON AUX CONTACT IN '0F1' SLOT

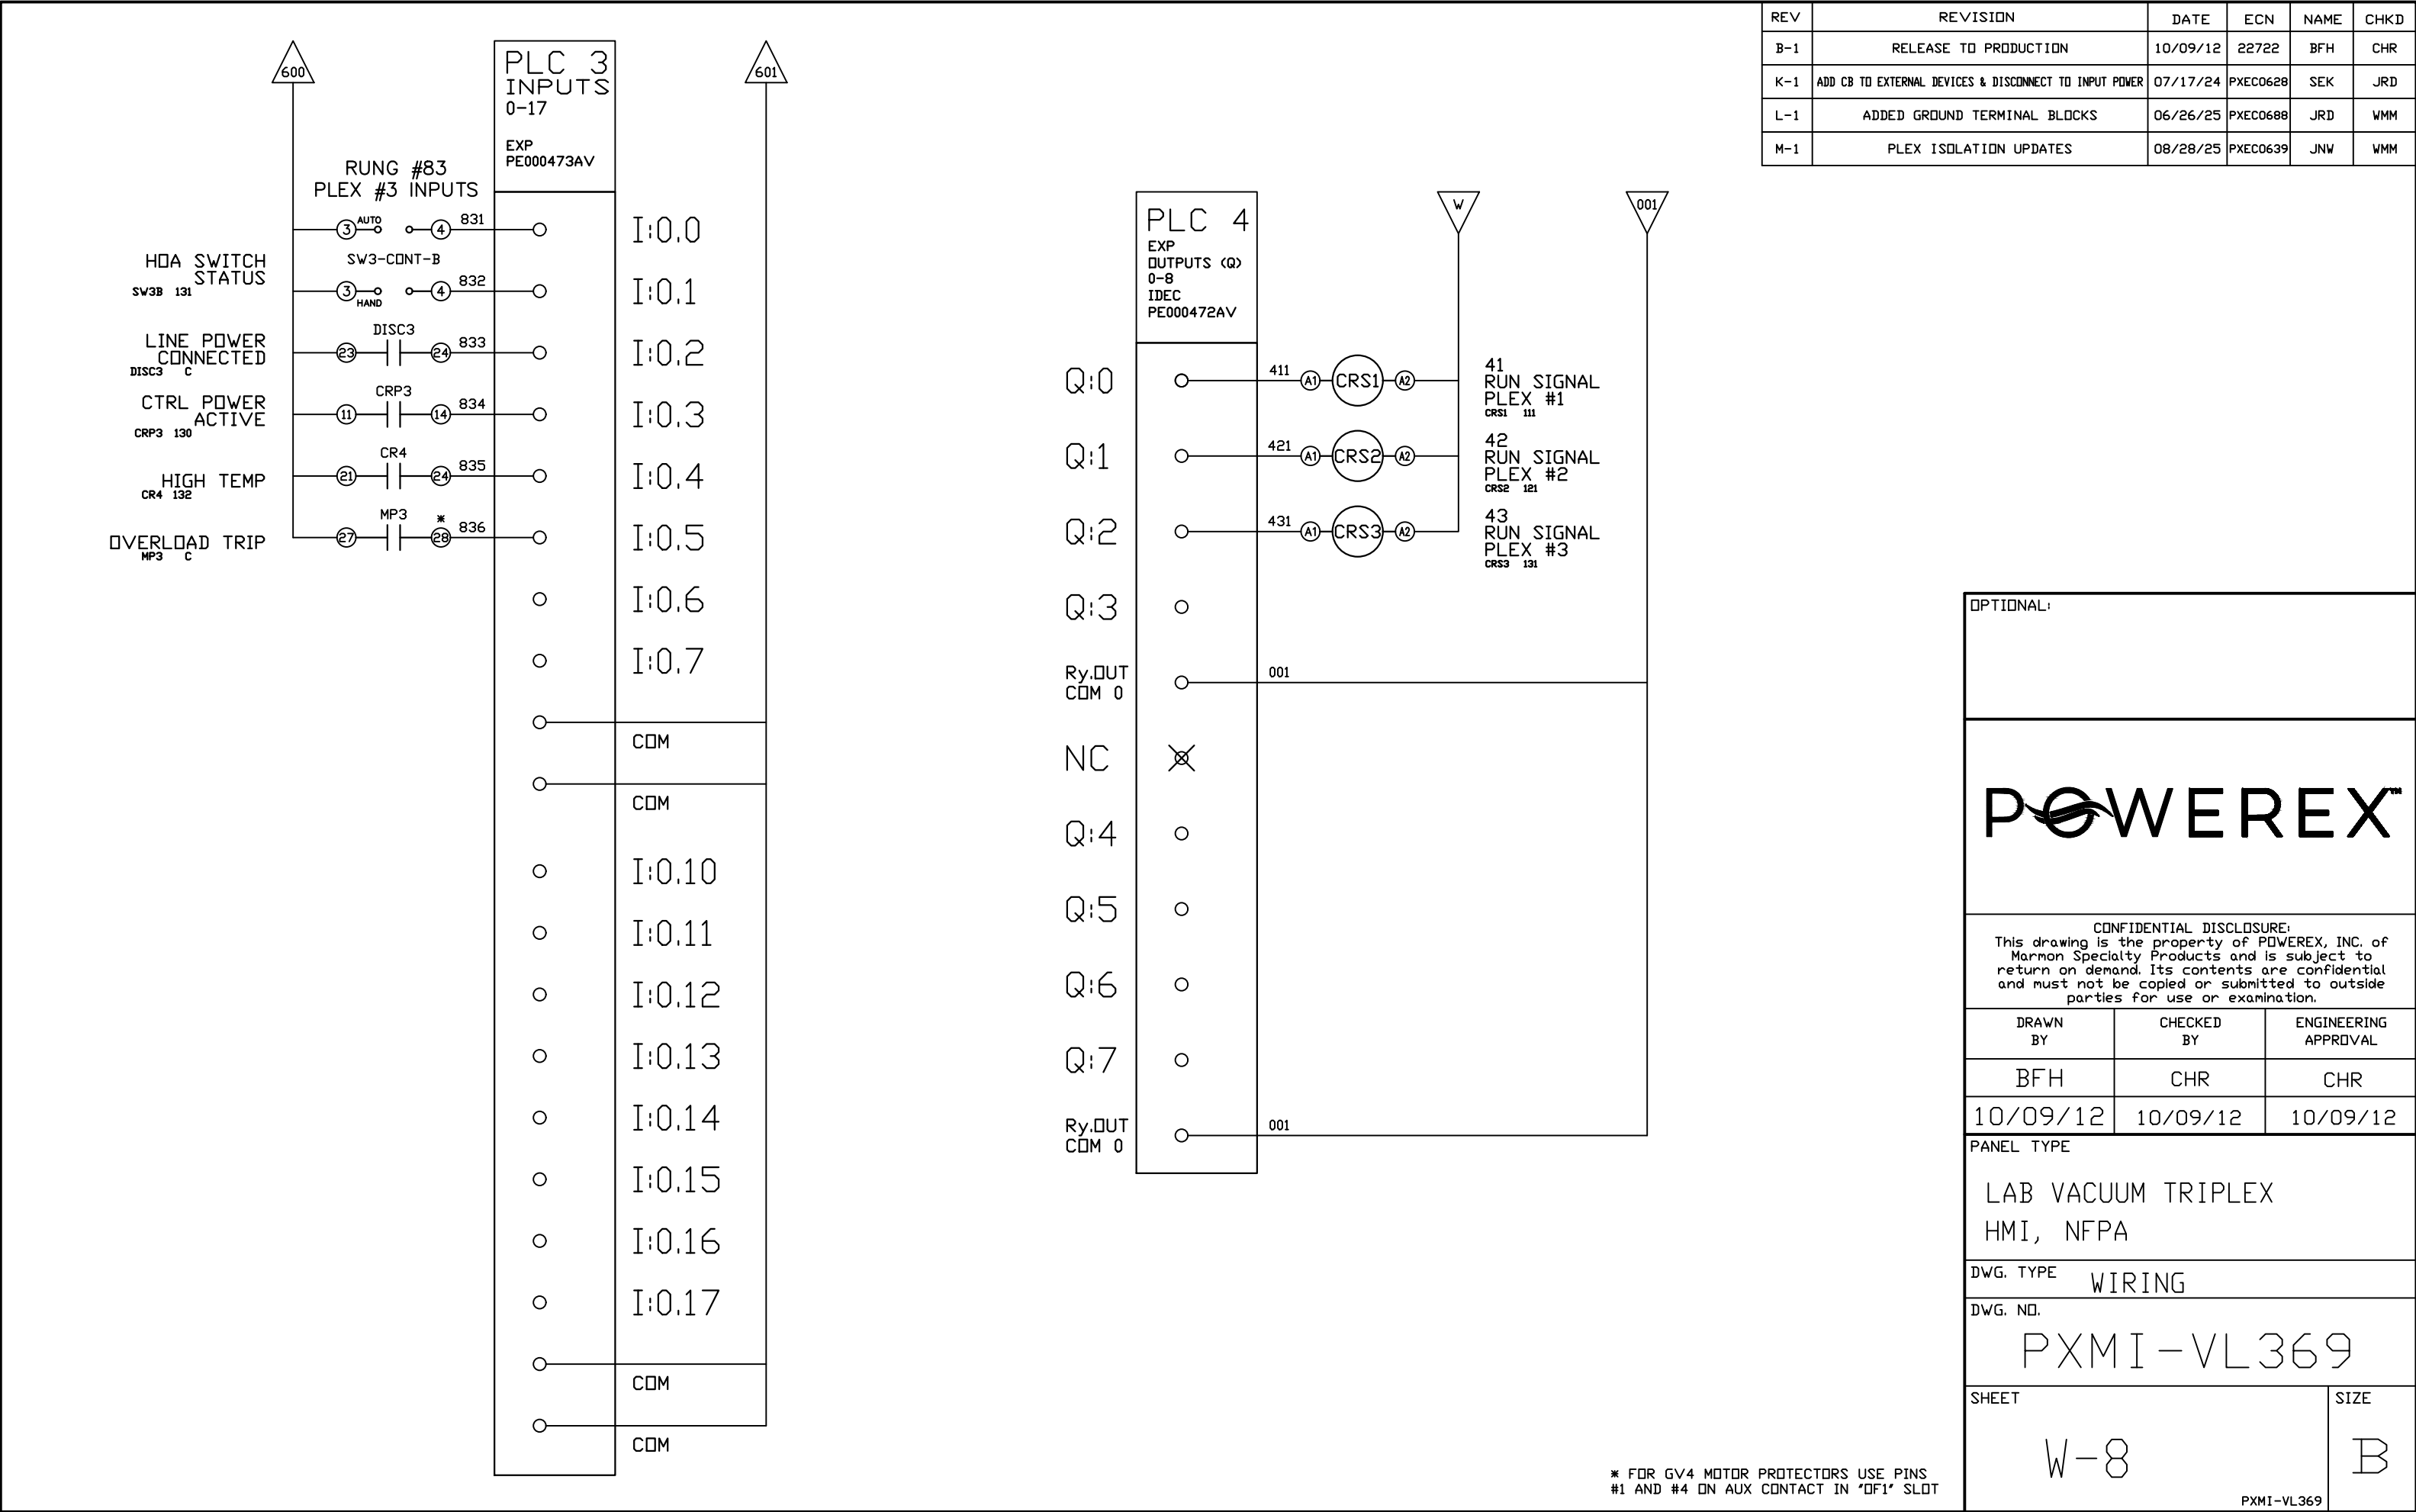

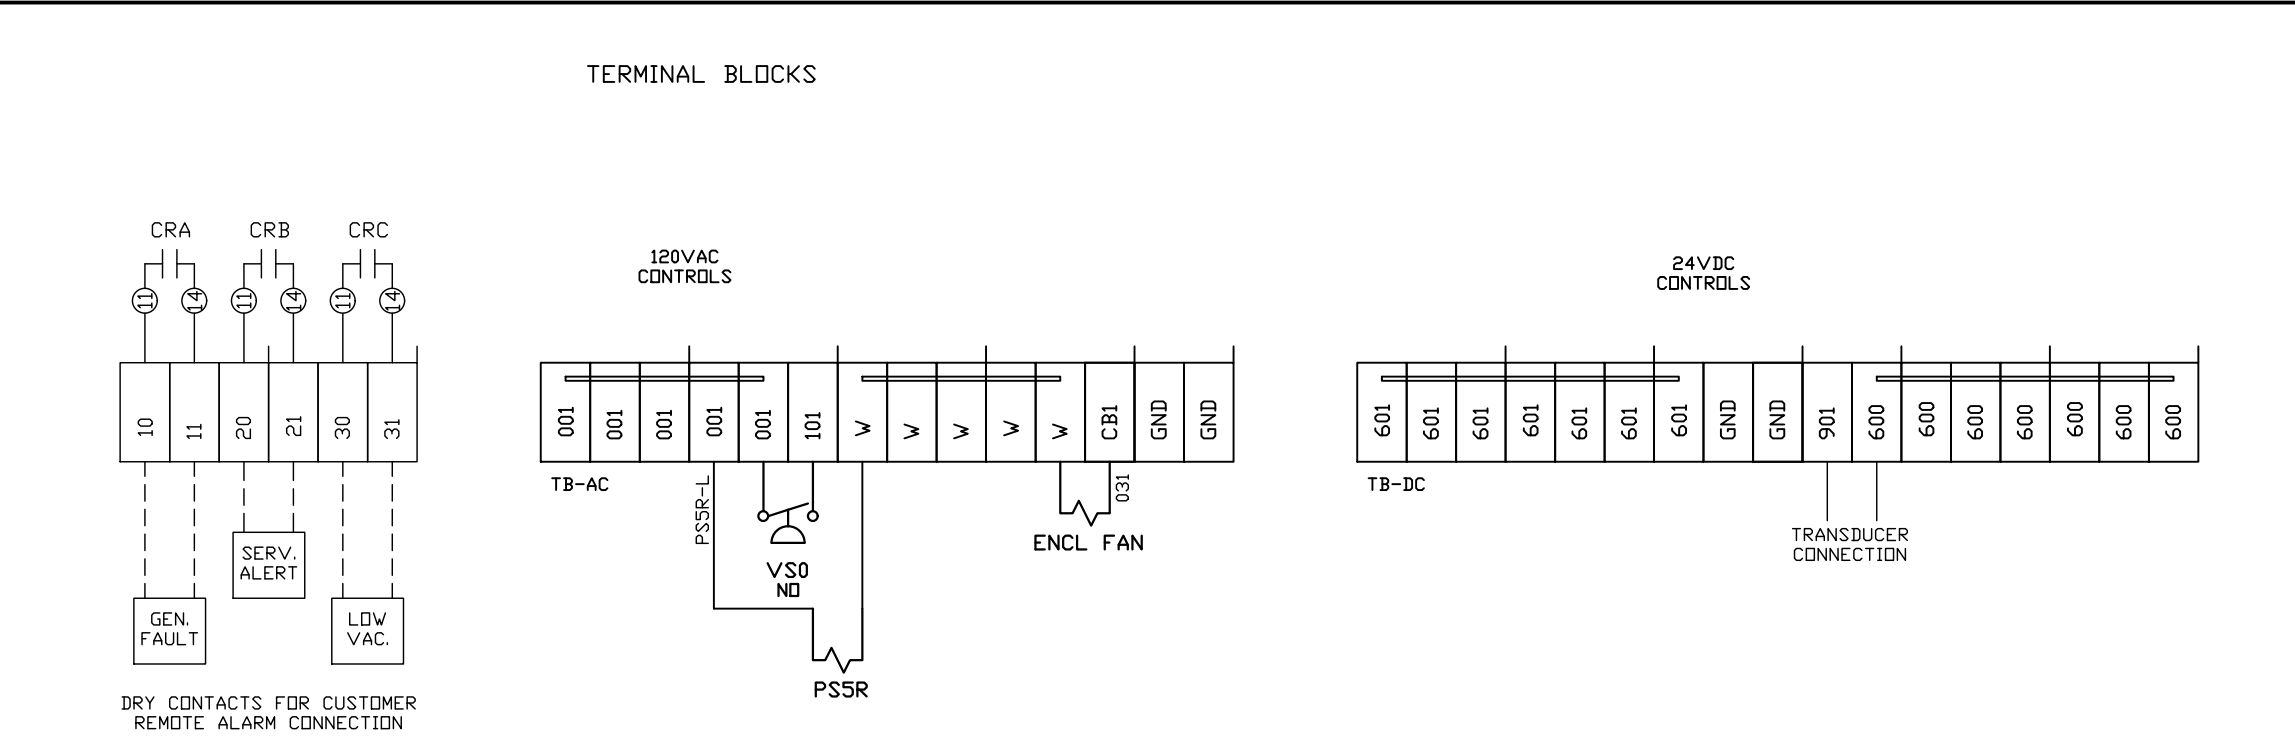

REV	REVISION	DATE	ECN	NAME	CHKD
B-1	RELEASE TO PRODUCTION	10/09/12	22722	BFH	CHR
K-1	ADD CB TO EXTERNAL DEVICES & DISCONNECT TO INPUT POWER	07/17/24	PXEC0628	SEK	JRD
L-1	ADDED GROUND TERMINAL BLOCKS	06/26/25	PXEC0688	JRD	WMM
M-1	PLEX ISOLATION UPDATES	08/28/25	PXEC0639	JNW	WMM

- FIELD WIRING NOTES:
- PANEL GROUND MUST BE CONNECTED TO EARTH GROUND
 - TRANSFORMER IS SIZED FOR LOADS SHOWN ON DRAWING ONLY.
 - FIELD WIRING INDICATED BY -----, WIRE TO BE COPPER RATED AT 75° C.
 - ALL ALARM DRY CONTACTS ARE CLOSED FOR NORMAL OPERATION AND OPEN IN ALARM.
 - DRY CONTACT RATING: 30V DC/2A (resistive load, inductive load L/R = 7 ms)
 - USE CAT-5 CABLE W/RJ45 CONNECTOR FOR ETHERNET CONNECTION TO COMMUNICATION NETWORK OR BAS SYSTEM

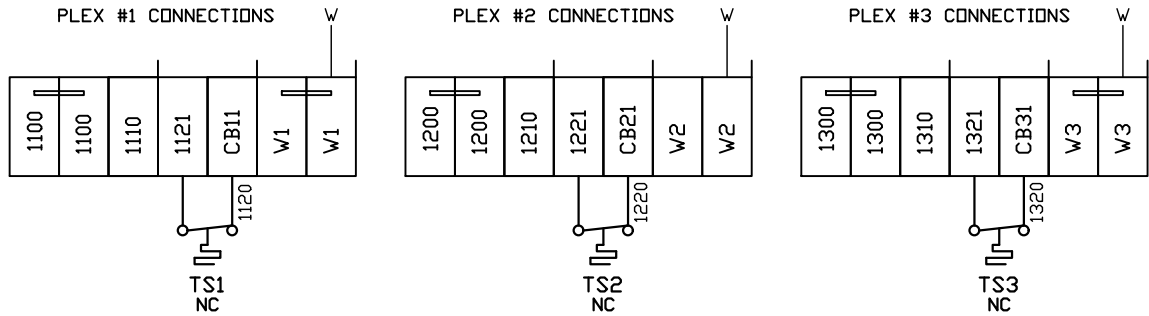

OPTIONAL:



CONFIDENTIAL DISCLOSURE:

This drawing is the property of POWEREX, INC. of Marnon Specialty Products and is subject to return on demand. Its contents are confidential and must not be copied or submitted to outside parties for use or examination.

DRAWN BY	CHECKED BY	ENGINEERING APPROVAL
BFH	CHR	CHR
10/09/12	10/09/12	10/09/12

PANEL TYPE

LAB VACUUM TRIPLEX
HMI, NFPA

DWG. TYPE WIRING


DWG. NO.

PXMI-VL369

SHEET	SIZE
W-9	B

PXMI-VL369

REV	REVISION	DATE	ECN	NAME	CHKD
B-1	RELEASE TO PRODUCTION	10/09/12	22722	BFH	CHR
K-1	ADD CB TO EXTERNAL DEVICES & DISCONNECT TO INPUT POWER	07/17/24	PXEC0628	SEK	JRD
L-1	ADDED GROUND TERMINAL BLOCKS	06/26/25	PXEC0688	JRD	WMM
M-1	PLEX ISOLATION UPDATES	08/28/25	PXEC0639	JNW	WMM

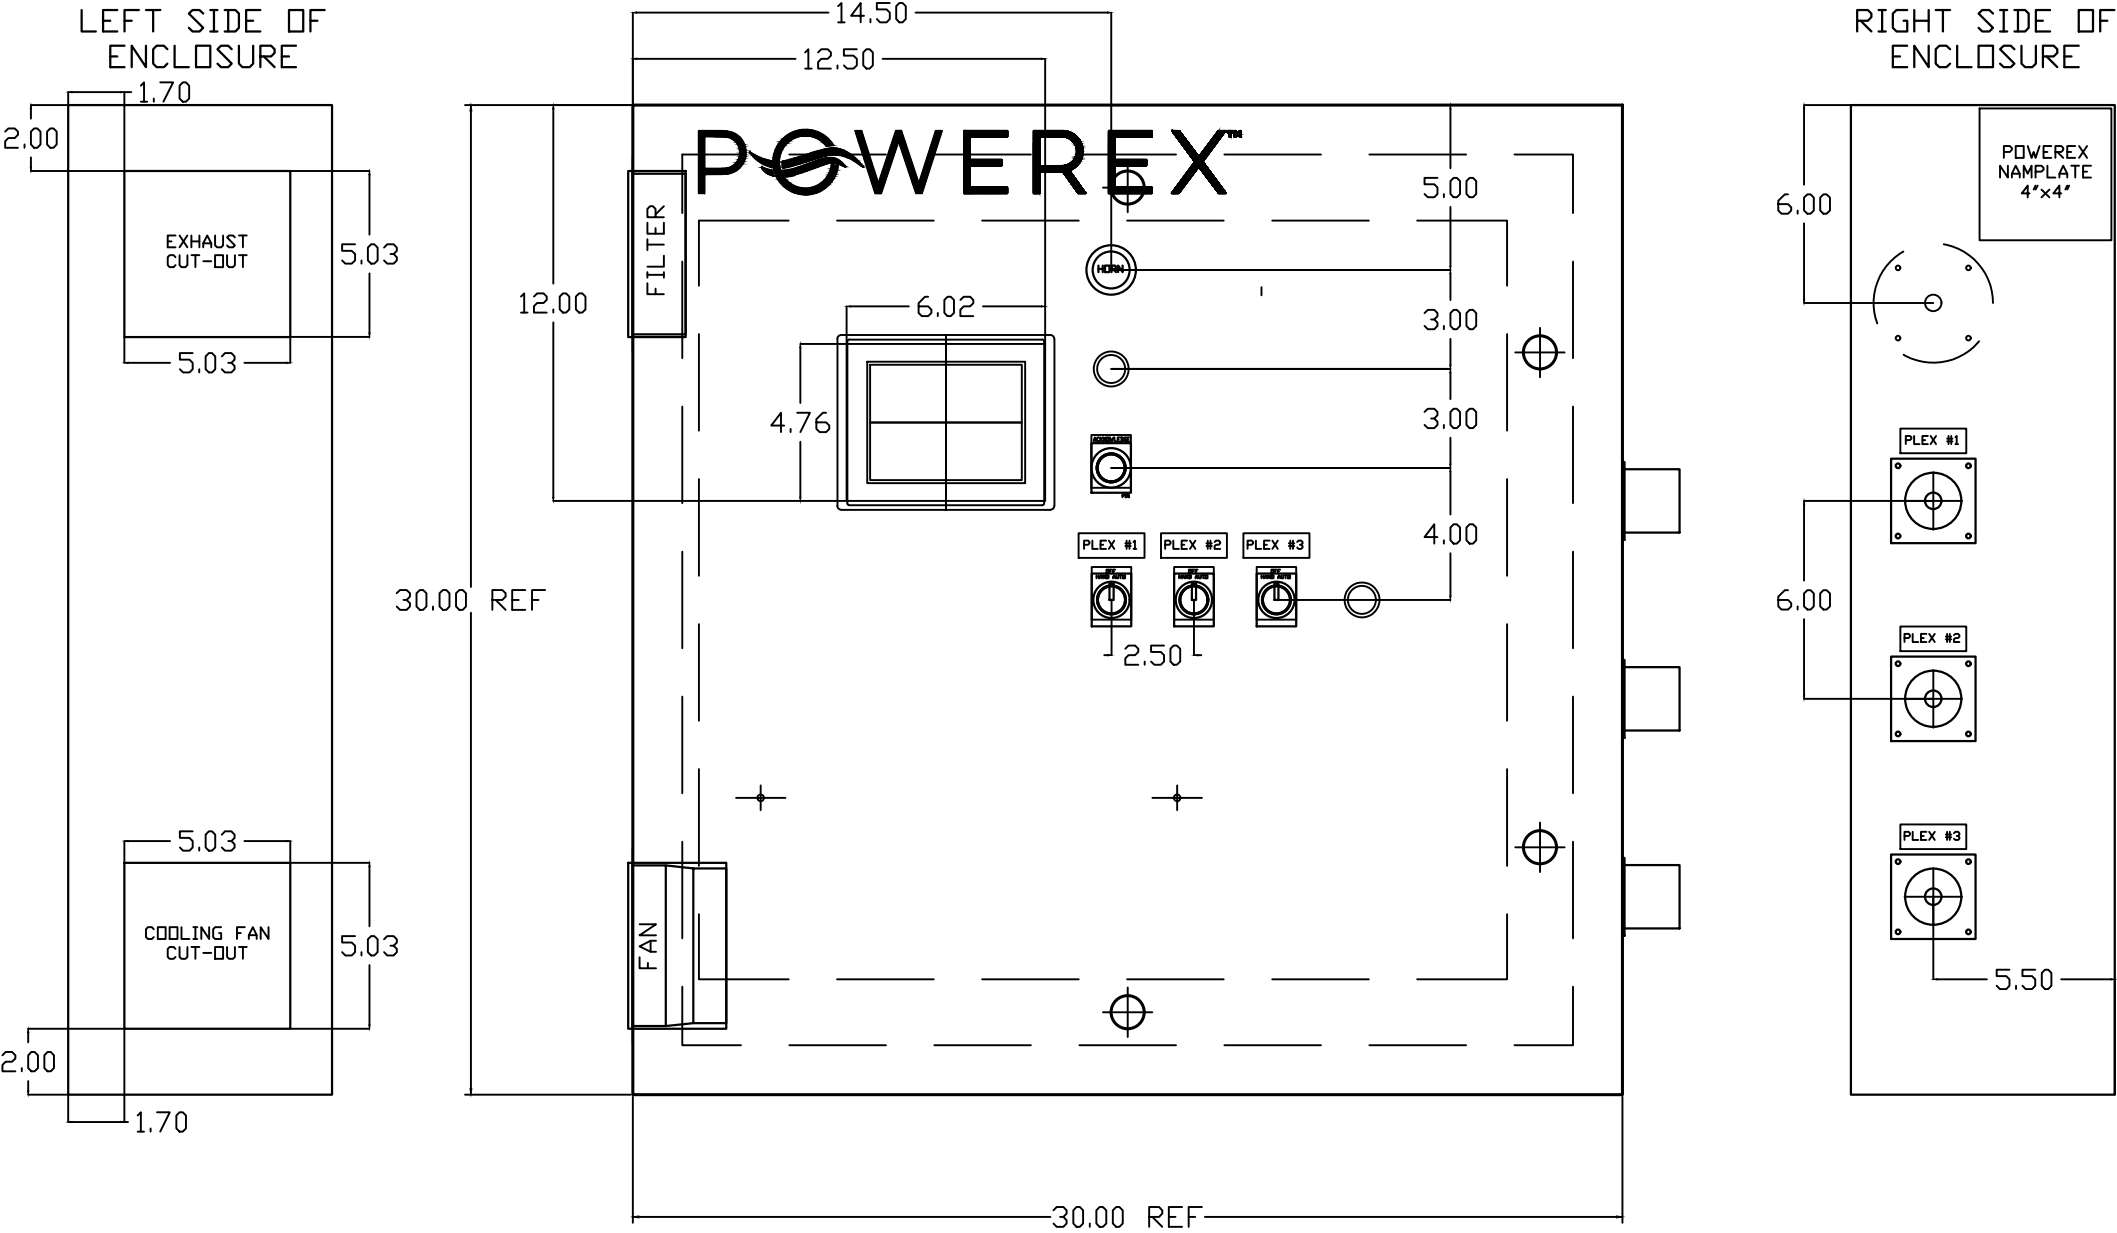

OPTIONAL:

CONFIDENTIAL DISCLOSURE:
This drawing is the property of POWEREX, INC. of
Marnon Specialty Products and is subject to
return on demand. Its contents are confidential
and must not be copied or submitted to outside
parties for use or examination.

DRAWN BY	CHECKED BY	ENGINEERING APPROVAL
BFH	CHR	CHR
10/09/12	10/09/12	10/09/12

PANEL TYPE

LAB VACUUM TRIPLEX
HMI, NFPA

DWG. TYPE LAYOUT


DWG. NO.

PXMI-VL369

SHEET	SIZE
LA-1	B

PXMI-VL369

REV	REVISION	DATE	ECN	NAME	CHKD
B-1	RELEASE TO PRODUCTION	10/09/12	22722	BFH	CHR
K-1	ADD CB TO EXTERNAL DEVICES & DISCONNECT TO INPUT POWER	07/17/24	PXEC0628	SEK	JRD
L-1	ADDED GROUND TERMINAL BLOCKS	06/26/25	PXEC0688	JRD	WMM
M-1	PLEX ISOLATION UPDATES	08/28/25	PXEC0639	JNW	WMM

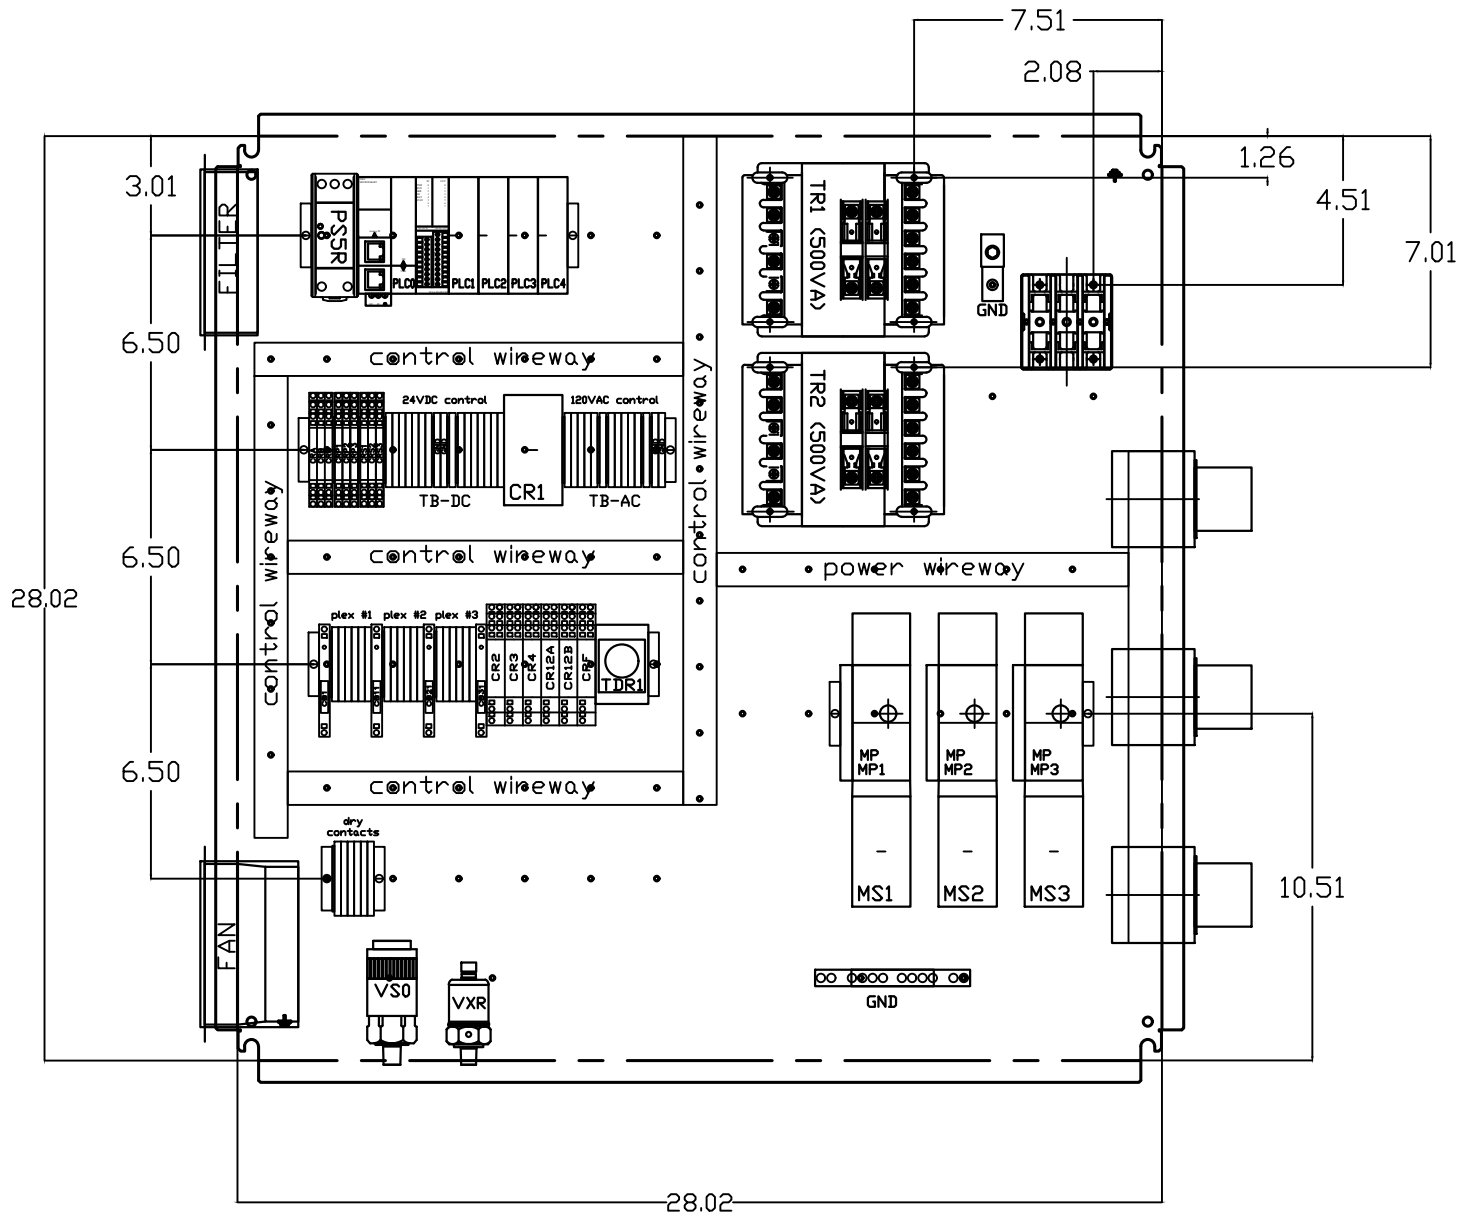

OPTIONAL:



CONFIDENTIAL DISCLOSURE:
This drawing is the property of POWEREX, INC. of
Marion Specialty Products and is subject to
return on demand. Its contents are confidential
and must not be copied or submitted to outside
parties for use or examination.

DRAWN BY	CHECKED BY	ENGINEERING APPROVAL
BFH	CHR	CHR
10/09/12	10/09/12	10/09/12

PANEL TYPE

LAB VACUUM TRIPLEX
HMI, NFPA

DWG. TYPE LAYOUT


DWG. NO.

PXMI-VL369

SHEET	SIZE
LA-2	B

PXMI-VL369

REV	REVISION	DATE	ECN	NAME	CHKD
B-1	RELEASE TO PRODUCTION	10/09/12	22722	BFH	CHR
K-1	ADD CB TO EXTERNAL DEVICES & DISCONNECT TO INPUT POWER	07/17/24	PXEC0628	SEK	JRD
L-1	ADDED GROUND TERMINAL BLOCKS	06/26/25	PXEC0688	JRD	WMM
M-1	PLEX ISOLATION UPDATES	08/28/25	PXEC0639	JNW	WMM

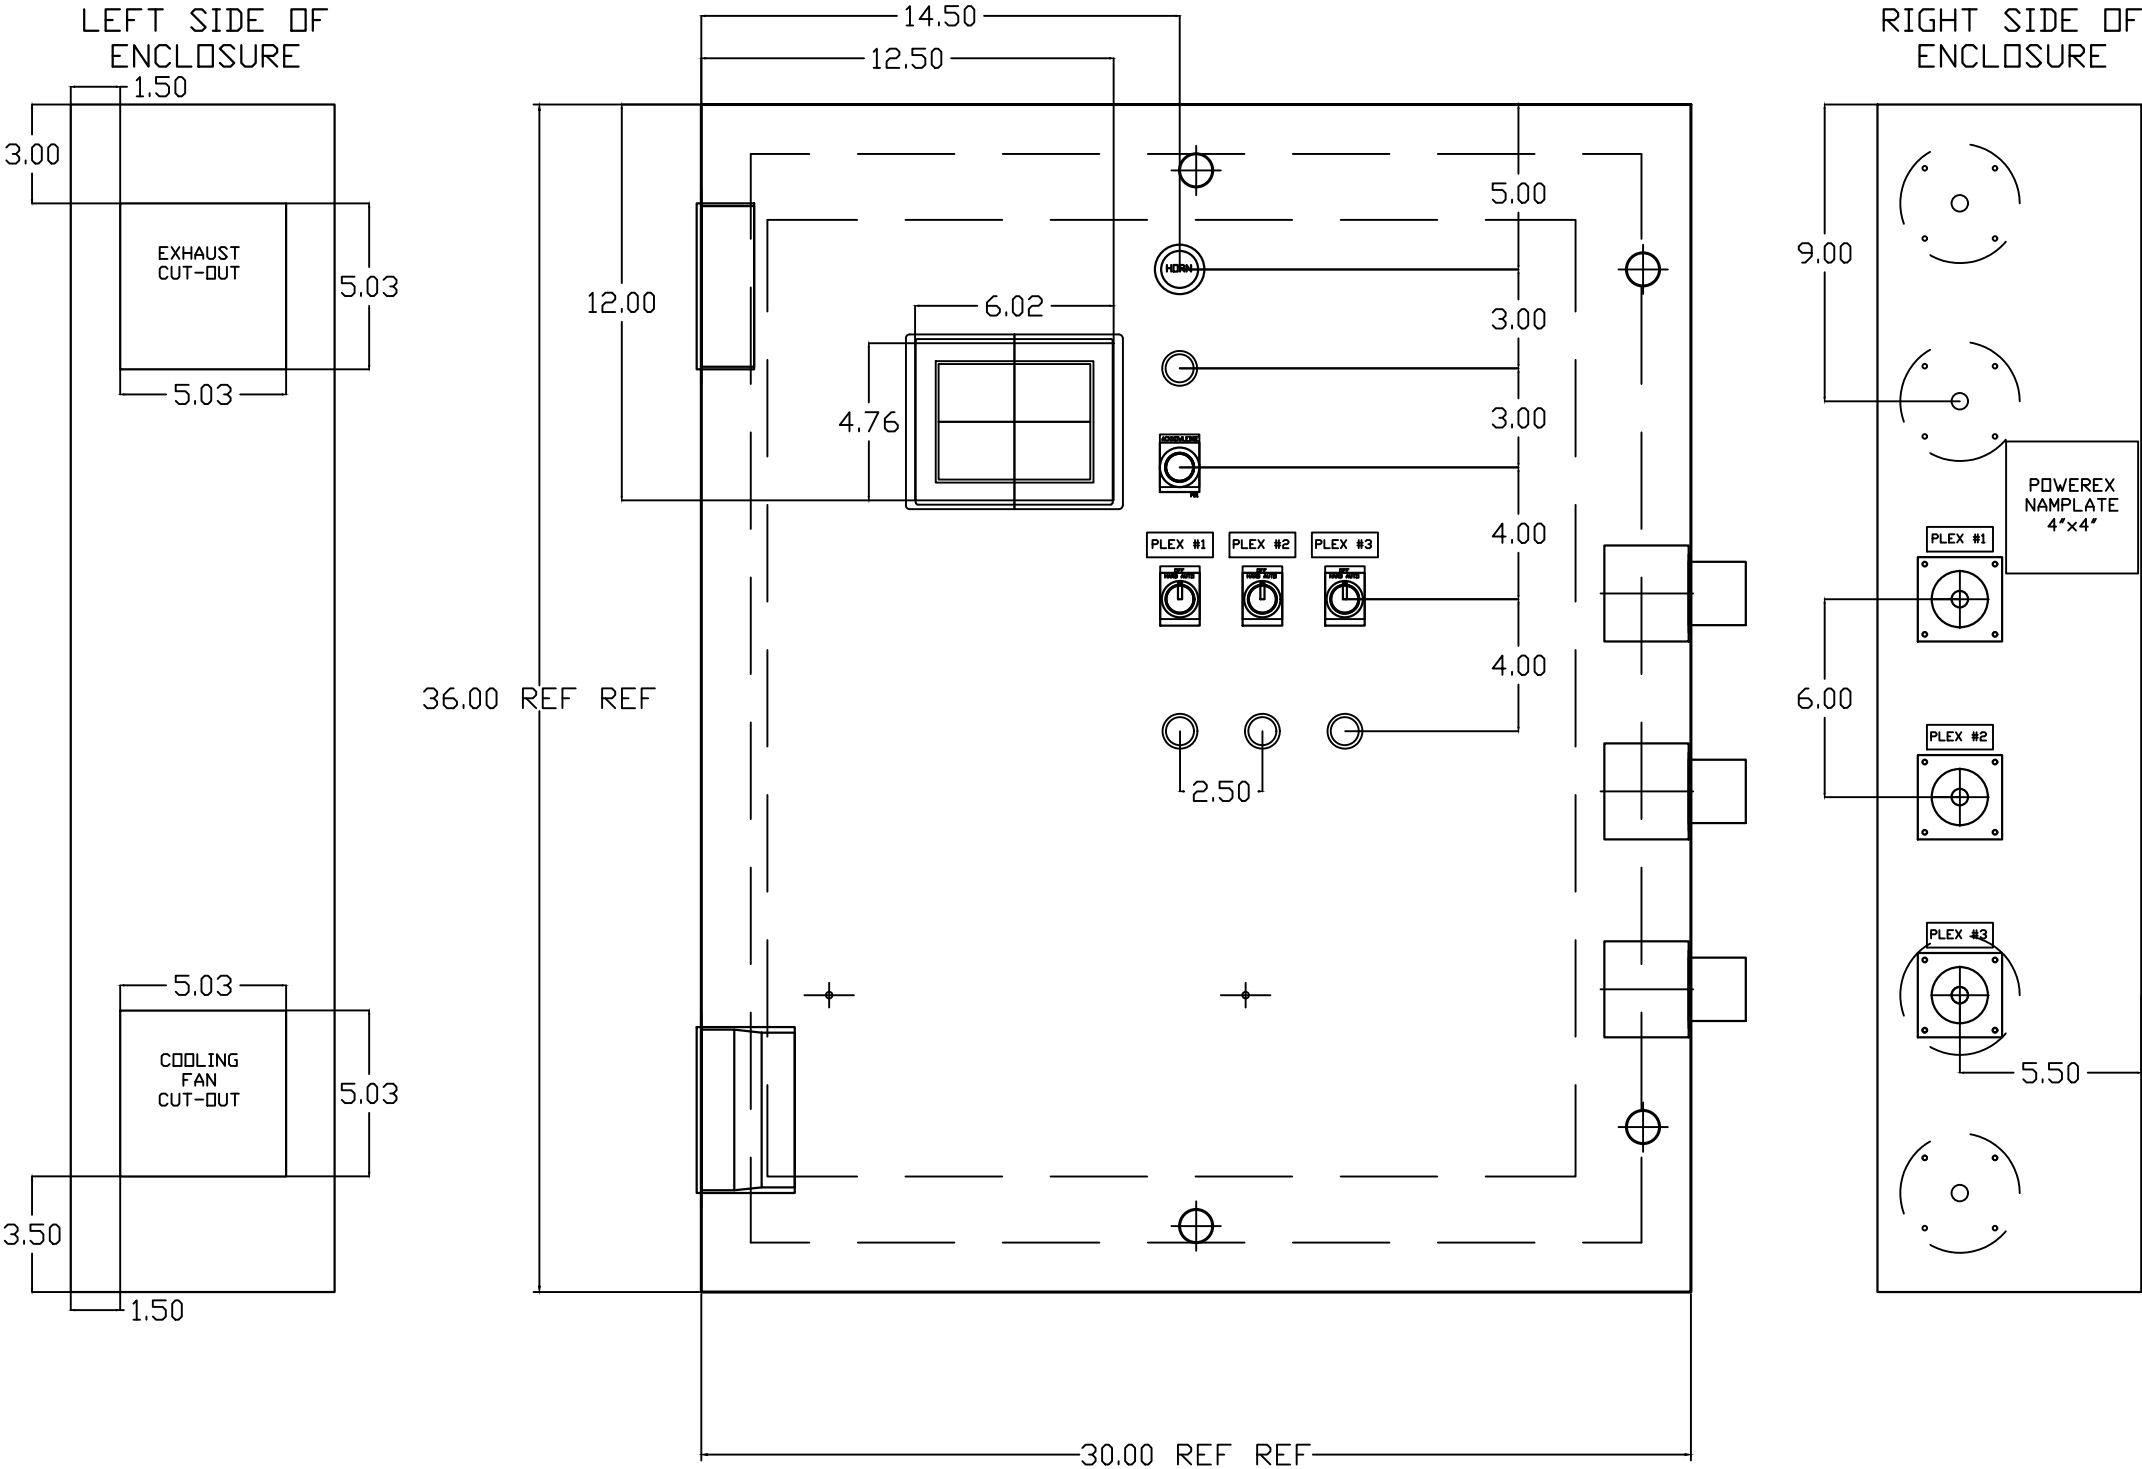

OPTIONAL:

CONFIDENTIAL DISCLOSURE:

This drawing is the property of POWEREX, INC. of Marmion Specialty Products and is subject to return on demand. Its contents are confidential and must not be copied or submitted to outside parties for use or examination.

DRAWN BY	CHECKED BY	ENGINEERING APPROVAL
BFH	CHR	CHR
10/09/12	10/09/12	10/09/12

PANEL TYPE

LAB VACUUM TRIPLEX
HMI, NFPA


DWG. TYPE LAYOUT

DWG. NO.

PXMI-VL369

SHEET	SIZE
LB-1	B

PXMI-VL369

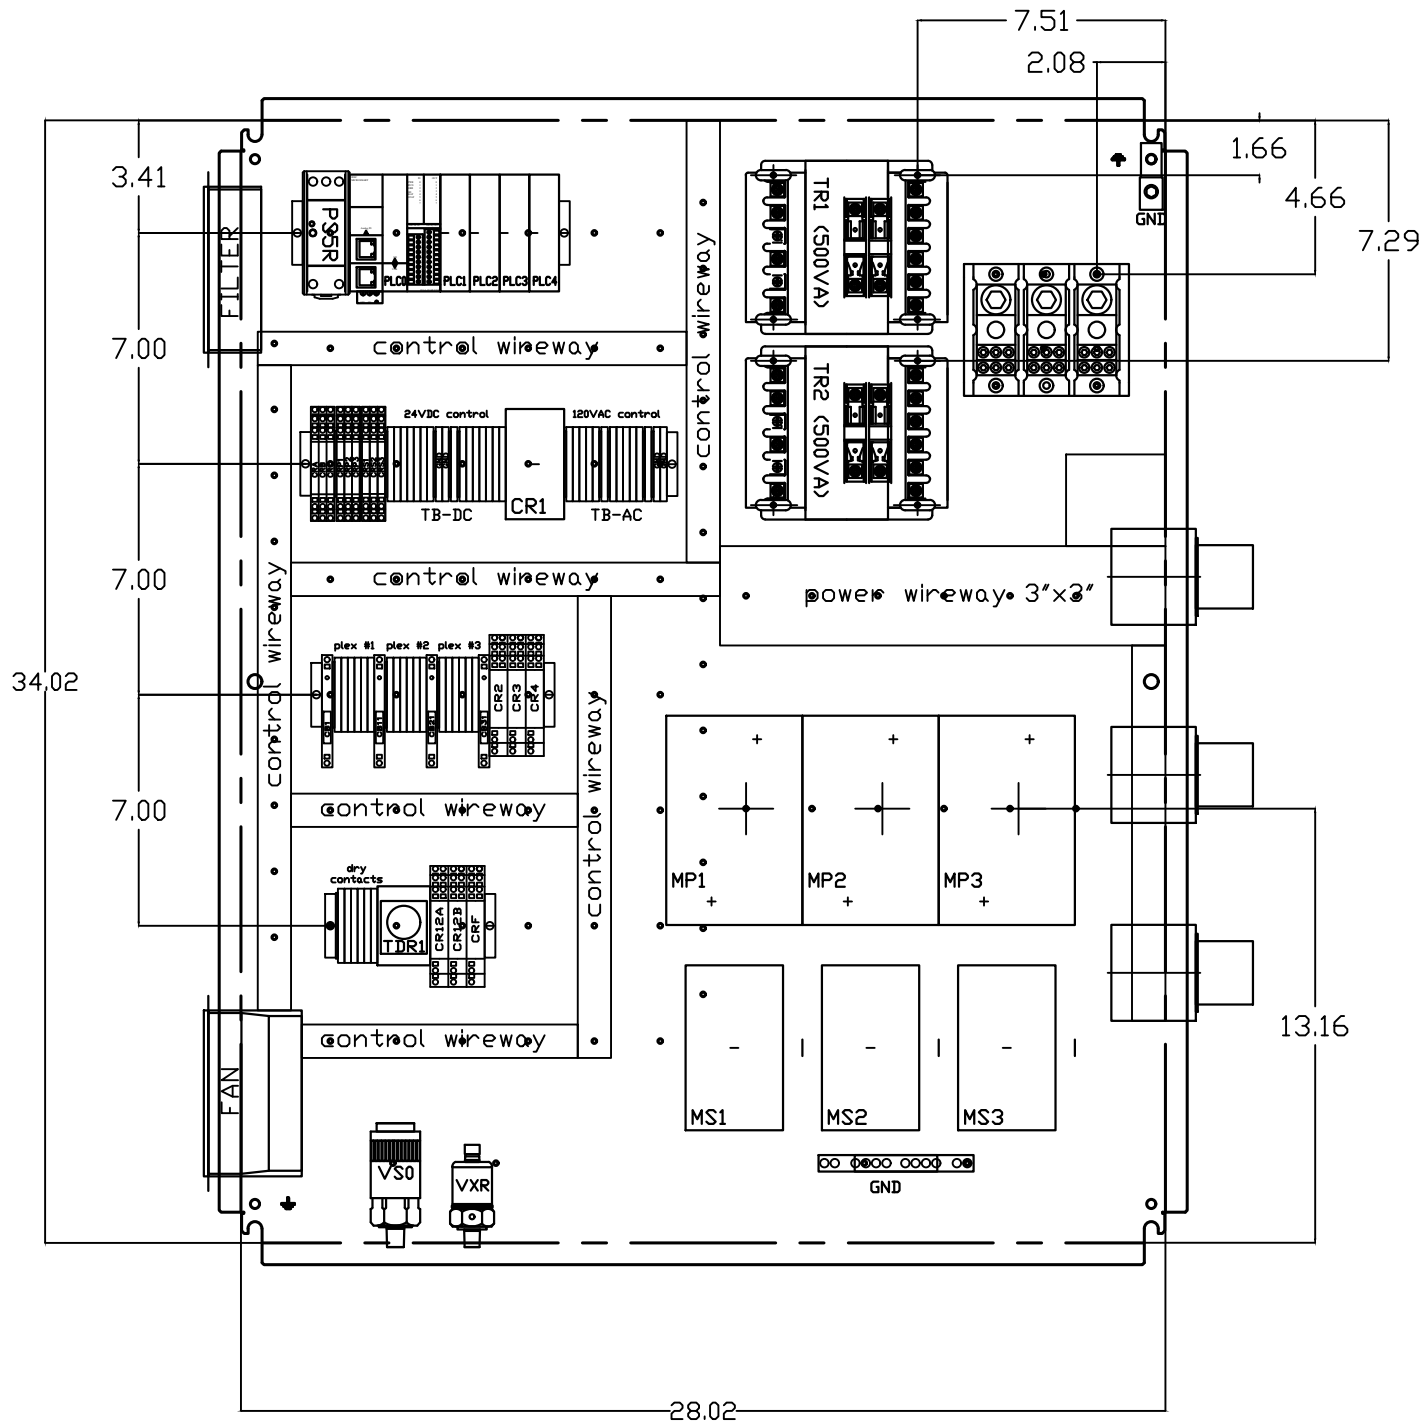

REV	REVISION	DATE	ECN	NAME	CHKD
B-1	RELEASE TO PRODUCTION	10/09/12	22722	BFH	CHR
K-1	ADD CB TO EXTERNAL DEVICES & DISCONNECT TO INPUT POWER	07/17/24	PXEC0628	SEK	JRD
L-1	ADDED GROUND TERMINAL BLOCKS	06/26/25	PXEC0688	JRD	WMM
M-1	PLEX ISOLATION UPDATES	08/28/25	PXEC0639	JNW	WMM

OPTIONAL:

CONFIDENTIAL DISCLOSURE:
This drawing is the property of POWEREX, INC. of
Marmion Specialty Products and is subject to
return on demand. Its contents are confidential
and must not be copied or submitted to outside
parties for use or examination.

DRAWN BY	CHECKED BY	ENGINEERING APPROVAL
BFH	CHR	CHR
10/09/12	10/09/12	10/09/12

PANEL TYPE

LAB VACUUM TRIPLEX
HMI, NFPA

DWG. TYPE LAYOUT

DWG. NO. PXMI-VL369

SHEET	SIZE
LB-2	B

PXMI-VL369

TABLE 1	P/N	MOTOR FULL LOAD AMPS	TOTAL FULL LOAD AMPS	NON-TIME DELAY FUSE	TIME DELAY FUSE	INVERSE- TIME CIRCUIT BREAKER
208V (3Ø)	02AB	3.4	12.2	20	15	20
	12AB	5	17	30	25	25
	22AB	6	20	35	25	30
	32AB	9	29	50	40	45
	42AB	15	47	80	60	70
	52AB	14.8	46.4	80	60	70
	72AB	26.2	80.6	150	100	125
	A2AB	33.4	102.2	175	150	175
	F2AB *	40.4	123.2	225	175	200
	G2AB *	62	188	350	250	300
	H2AB *	68	206	350	300	350
230V (3Ø)	03AB	3.4	12.2	20	15	20
	13AB	4.4	15.2	25	20	25
	23AB	5.4	18.2	30	25	30
	33AB	7.8	25.4	45	35	40
	43AB	13.2	41.6	70	60	70
	53AB	12.9	40.7	70	60	70
	73AB	20.9	64.7	110	90	100
	A3AB	26.2	80.6	150	100	125
	F3AB *	38.8	118.4	200	150	200
	G3AB *	52	158	300	200	250
	H3AB *	62	188	350	250	300
460V (3Ø)	04AB	2	8	15	10	15
	14AB	2.2	8.6	15	10	15
	24AB	2.7	10.1	20	15	15
	34AB	3.9	13.7	25	20	25
	44AB	6.6	21.8	35	30	35
	54AB	6.5	21.5	35	30	35
	74AB	10.5	33.5	60	45	50
	A4AB	13.1	41.3	70	60	70
	F4AB	19.4	60.2	100	80	90
	G4AB	26	80	150	100	125
	H4AB *	31	95	175	125	150
380V (3Ø)	08AB	N/A				
	18AB	2.5	9.5	15	15	15
	28AB	3.1	11.3	20	15	20
	38AB	4.6	15.8	25	20	25
	48AB	7.3	23.9	40	30	40
	58AB	7.7	25.1	45	35	40
	78AB	11.9	37.7	70	50	60
	A8AB	13.3	41.9	70	60	70
	F8AB	22.3	68.9	125	90	110
	G8AB *	28	86	150	110	150
	H8AB *	37	113	200	150	175

NOTE: P/N MAY INCLUDE SUFFIX AV

NOTES:

1. RECOMMENDED TIGHTENING TORQUES FOR WIRE TERMINALS:
208-575 VOLT POWER 35 POUND INCHES
120 VOLT POWER AND CONTROL VOLTAGE 15 POUND INCHES
2. PANEL GROUND MUST BE CONNECTED TO EARTH GROUND
3. INSTALLER TO PROVIDE MAIN DISCONNECTING DEVICE FOR THIS ELECTRICAL ASSEMBLY. SHORT CIRCUIT PROTECTION IS RECOMMENDED, SEE TABLE 1. IF PROVIDING PANEL SHORT CIRCUIT PROTECTION USING CLASS J TIME DELAY FUSES, PANEL SCCR IS 65KA. OTHERWISE, PANEL SCCR IS 5KA.
4. ALL WIRES MUST BE LABELED ON BOTH ENDS
5. TRANSFORMER IS SIZED FOR LOADS SHOWN ON DRAWING ONLY. DO NOT CONNECT ANY OTHER DEVICES
6. △ -INDICATES A DRAWING WIRE CONNECTION TO ANOTHER PAGE.
7. SERVICE DISCONNECT USAGE - turn HOA switch to OFF position. Turn disconnect OF SAME UNIT to OFF position. Associated PLEX will be isolated for maintenance purposes. After completing maintenance, turn disconnect to ON position and return HOA switch to AUTO. This will return PLEX to normal operation.

CONTROL TRANSFORMERS - 500VA						WIRE TYPE TABLE			
REPLACEMENT	208	230	460	575					
FUSE TYPE	VOLT	VOLT	VOLT	VOLT		VOLTAGE	WIRE NUMBERS	GAUGE	COLOR
FU1,2A	FNQR	6A	5A	5A	4A	120VAC	001-599,1100+	16-18AWG	RED/BLK
FU1,2B						0VAC	W	16-18AWG	WHT/BLK
						24VDC	600-1099	16-18AWG	PURPLE
FU3A,B	FNM	7A	7A	7A	7A	0VDC	601	16-18AWG	PURPLE
						GND	-	VARIES	GREEN
						CUSTOMER SUPPLY	01-99	16-18AWG	YELLOW
SEE XFMR FOR CONNECTIONS									

SEQUENCE OF OPERATIONS

During normal operation the PBMI controller will signal the Lead pump to run when vacuum drops to lead cut-in set-point and run for a 10-minute minimum period before stopping when the vacuum reaches the lead cut-out set-point. Lead alternation to the next pump, will occur every 30-minutes. If demand cannot be satisfied by the lead pump, the lag pump(s) will start and stop based upon the lag cut-in and cut-out set-points. The HOA switch’s place the pump in the following modes: Hand-turns pump on to run continuous. Off-disables pump from running. Auto-places pump in the “ready mode” and will start and stop based on sequence described above.

Expandable systems include all control devices, operators, and programming for the maximum number of pumps (or plex) required. To expand the system: navigate to the “service screen” and enter the number of pumps.

Additional information and descriptions can be accessed through the HMI “service info” screen by pressing Sequence of Operations button.

REV	REVISION	DATE	ECN	NAME	CHKD
B-1	RELEASE TO PRODUCTION	09/01/11	22545	BFH	CHR
C-1	ADD 380V DATA	02/28/13	PXEC0030	BFH	CHR
C-2	FORMAT UPDATE	03/01/13	PXEC0038	BFH	CHR

OPTIONAL:

208V/230V/380/460V



CONFIDENTIAL DISCLOSURE:
This drawing is the property of the CAMPBELL GROUP of the SCOTT FETZER COMPANY and subject to return on demand. Its contents are confidential and must not be copied or submitted to outside parties for use or examination.

DRAWN BY	CHECKED BY	ENGINEERING APPROVAL
BFH	CHR	CHR
09/01/11	09/20/11	09/20/11

PANEL TYPE
BUSCH LUBRICATED VANE
3PH TRIPLEX PANEL DATA

DWG. TYPE
MISC

DWG. NO.
DATA TABLE

SHEET D-1	SIZE B
TRIPLEX PANEL DATA	

TABLE 1	P/N	MOTOR FULL LOAD AMPS	TOTAL FULL LOAD AMPS	NON-TIME DELAY FUSE	TIME DELAY FUSE	INVERSE-TIME CIRCUIT BREAKER
208V (3Ø)	22CB	6.6	21.8	40	30	35
	32CB	9.4	30.2	50	40	45
	42CB	10.4	33.2	60	45	50
	52CB	12.4	39.2	70	50	60
	62CB	16.4	51.2	90	70	80
	72CB	21.4	66.2	110	90	100
	A2CB	27.2	83.6	150	110	125
	F2CB *	40.5	123.5	225	175	200
230V (3Ø)	23CB	5.6	18.8	35	25	30
	33CB	8.4	27.2	45	35	45
	43CB	9.2	29.6	50	40	45
	53CB	11.4	36.2	60	50	60
	63CB	15.2	47.6	80	60	80
	73CB	17.2	53.6	90	70	80
	A3CB	23.6	72.8	125	100	110
	F3CB *	35.0	107.0	200	150	175
460V (3Ø)	24CB	2.8	10.4	20	15	15
	34CB	4.2	14.6	25	20	25
	44CB	4.6	15.8	25	20	25
	54CB	5.7	19.1	30	25	30
	64CB	7.6	24.8	40	30	40
	74CB	8.6	27.8	45	35	45
	A4CB	11.3	35.9	60	45	60
	F4CB	17.5	54.5	90	70	90
380V (3Ø) 50HZ	28CB	2.6	9.8	15	15	15
	38CB	3.8	13.4	25	20	20
	48CB	5.0	17.0	30	25	25
	58CB	5.1	17.3	30	25	25
	68CB	8.6	27.8	45	35	45
	78CB	9.3	29.9	50	40	45
	A8CB	10.5	33.5	60	45	50
	F8CB	14.5	45.5	80	60	70

NOTE: P/N MAY INCLUDE SUFFIX AV

NOTES:

1. RECOMMENDED TIGHTENING TORQUES FOR WIRE TERMINALS:
208-575 VOLT POWER 35 POUND INCHES
120 VOLT POWER AND CONTROL VOLTAGE 15 POUND INCHES
2. PANEL GROUND MUST BE CONNECTED TO EARTH GROUND
3. INSTALLER TO PROVIDE MAIN DISCONNECTING DEVICE FOR THIS ELECTRICAL ASSEMBLY. SHORT CIRCUIT PROTECTION IS RECOMMENDED, SEE TABLE 1. IF PROVIDING PANEL SHORT CIRCUIT PROTECTION USING CLASS J TIME DELAY FUSES, PANEL SCCR IS 65KA. OTHERWISE, PANEL SCCR IS 5KA.
4. ALL WIRES MUST BE LABELED ON BOTH ENDS
5. TRANSFORMER IS SIZED FOR LOADS SHOWN ON DRAWING ONLY. DO NOT CONNECT ANY OTHER DEVICES
6. Δ -INDICATES A DRAWING WIRE CONNECTION TO ANOTHER PAGE.
7. SERVICE DISCONNECT USAGE - turn HOA switch to OFF position. Turn disconnect OF SAME UNIT to OFF position. Associated PLEX will be isolated for maintenance purposes. After completing maintenance, turn disconnect to ON position and return HOA switch to AUTO. This will return PLEX to normal operation.

CONTROL TRANSFORMERS - 500VA						WIRE TYPE TABLE			
REPLACEMENT	208	230	460 380	575					
FUSE TYPE		VOLT	VOLT	VOLT	VOLT	VOLTAGE	WIRE NUMBERS	GAUGE	COLOR
FU1,2A FU1,2B	FNQR	6A	5A	5A	4A	120VAC 0VAC 24VDC	001-599,1100+ W 600-1099	16-18AWG 16-18AWG 16-18AWG	RED/BLK WHT/BLK PURPLE
FU3A,B	FNM	7A	7A	7A	7A	0VDC GND	601 -	16-18AWG VARIES	PURPLE GREEN
SEE XFMR FOR CONNECTIONS						CUSTOMER SUPPLY	01-99	16-18AWG	YELLOW

SEQUENCE OF OPERATIONS

During normal operation the PBMI controller will signal the Lead pump to run when vacuum drops to lead cut-in set-point and run for a 10-minute minimum period before stopping when the vacuum reaches the lead cut-out set-point. Lead alternation to the next pump, will occur every 30-minutes. If demand cannot be satisfied by the lead pump, the lag pump(s) will start and stop based upon the lag cut-in and cut-out set-points. The HOA switch’s place the pump in the following modes: Hand-turns pump on to run continuous. Off-disables pump from running. Auto-places pump in the “ready mode” and will start and stop based on sequence described above.

Expandable systems include all control devices, operators, and programming for the maximum number of pumps (or plex) required. To expand the system: navigate to the “service screen” and enter the number of pumps.

Additional information and descriptions can be accessed through the HMI “service info” screen by pressing Sequence of Operations button.

REV	REVISION	DATE	ECN	NAME	CHKD
B-1	RELEASE TO PRODUCTION	09/01/11	22545	BFH	CHR
C-1	CHANGED 10HP FLA VALUES	09/14/12	PXEC0013	BFH	CHR
D-1	FORMAT UPDATE	03/01/13	PXEC0038	BFH	CHR
E-1	UPDATED 52CB FLA DATA	01/22/14	PXEC0067	DMS	KMD
E-2	UPDATED 32CB FLA DATA	04/11/14	PXEC0067	DMS	KMD
F-1	UPDATED DATA - NEW NEMA MOTORS	06/14/16	PXEC0149	KMD	DMS

OPTIONAL: 200V/230V/380V/460V		
		
CONFIDENTIAL DISCLOSURE: This drawing is the property of the CAMPBELL GROUP of the SCOTT FETZER COMPANY and subject to return on demand. Its contents are confidential and must not be copied or submitted to outside parties for use or examination.		
DRAWN BY	CHECKED BY	ENGINEERING APPROVAL
BFH	CHR	CHR
09/01/11	09/20/11	09/20/11
PANEL TYPE BUSCH CLAW VACUUM 3PH TRIPLEX PANEL DATA		
DWG. TYPE MISC		
DWG. NO. DATA TABLE		
SHEET D-1		SIZE B
TRIPLEX PANEL DATA		

TABLE 1	P/N	MOTOR FULL LOAD AMPS	TOTAL FULL LOAD AMPS	NON-TIME DELAY FUSE	TIME DELAY FUSE	INVERSE-TIME CIRCUIT BREAKER
208V (3Ø)	12AJ	3.7	13.1	25	20	20
	22AJ	6.5	21.5	35	30	35
	32AJ	8.6	27.8	45	35	45
	52AJ	14.2	44.6	80	60	70
	72AJ	20.9	64.7	110	90	100
	62AJ	21	65	110	90	100
	A2AJ *	30	92	175	125	150
	C2AJ *	37.1	113.3	200	150	175
230V (3Ø)	13AJ	3.6	12.8	20	20	20
	23AJ	6.1	20.3	35	25	30
	33AJ	8	26	45	35	40
	53AJ	12.8	40.4	70	50	70
	73AJ	18.9	58.7	100	80	90
	63AJ	20	62	110	80	100
	A3AJ *	29.4	90.2	150	125	150
	C3AJ *	32.8	100.4	175	125	175
460V (3Ø)	14AJ	1.8	7.4	15	10	15
	24AJ	2.9	10.7	20	15	20
	34AJ	5.1	17.3	30	25	30
	54AJ	6.4	21.2	35	30	35
	74AJ	9.5	30.5	50	40	50
	64AJ	11.6	36.8	60	50	60
	A4AJ	15.3	47.9	80	60	80
	C4AJ	16.4	51.2	90	70	80
380V (3Ø)	18AJ		2	10	10	10
	28AJ	4	14	25	20	25
	38AJ	4.7	16.1	30	20	25
	58AJ	6.9	22.7	40	30	35
	78AJ	13	41	70	60	70
	68AJ	10.5	33.5	60	45	50
	A8AJ	15.9	49.7	90	70	80
	C8AJ					

NOTE: P/N MAY INCLUDE SUFFIX AV

- NOTES:
1. RECOMMENDED TIGHTENING TORQUES FOR WIRE TERMINALS:
208-575 VOLT POWER 35 POUND INCHES
120 VOLT POWER AND CONTROL VOLTAGE 15 POUND INCHES
 2. PANEL GROUND MUST BE CONNECTED TO EARTH GROUND
 3. INSTALLER TO PROVIDE MAIN DISCONNECTING DEVICE FOR THIS ELECTRICAL ASSEMBLY. SHORT CIRCUIT PROTECTION IS RECOMMENDED, SEE TABLE 1. IF PROVIDING PANEL SHORT CIRCUIT PROTECTION USING CLASS J TIME DELAY FUSES, PANEL SCCR IS 65KA. OTHERWISE, PANEL SCCR IS 5KA.
 4. ALL WIRES MUST BE LABELED ON BOTH ENDS
 5. TRANSFORMER IS SIZED FOR LOADS SHOWN ON DRAWING ONLY. DO NOT CONNECT ANY OTHER DEVICES
 6. △ -INDICATES A DRAWING WIRE CONNECTION TO ANOTHER PAGE.
 7. SERVICE DISCONNECT USAGE - turn HOA switch to OFF position. Turn disconnect OF SAME UNIT to OFF position. Associated PLEX will be isolated for maintenance purposes. After completing maintenance, turn disconnect to ON position and return HOA switch to AUTO. This will return PLEX to normal operation.

CONTROL TRANSFORMERS - 500VA					
REPLACEMENT		208	230	460 380	575
FUSE TYPE		VOLT	VOLT	VOLT	VOLT
FU1,2A FU1,2B	FNQR	6A	5A	5A	4A
FU3A,B	FNM	7A	7A	7A	7A
SEE XFMR FOR CONNECTIONS					

WIRE TYPE TABLE			
VOLTAGE	WIRE NUMBERS	GAUGE	COLOR
120VAC	001-599,1100+	16-18AWG	RED/BLK
0VAC	W	16-18AWG	WHT/BLK
24VDC	600-1099	16-18AWG	PURPLE
0VDC	601	16-18AWG	PURPLE
GND	-	VARIES	GREEN
CUSTOMER SUPPLY	01-99	16-18AWG	YELLOW

SEQUENCE OF OPERATIONS

During normal operation the PBMI controller will signal the Lead pump to run when vacuum drops to lead cut-in set-point and run for a 10-minute minimum period before stopping when the vacuum reaches the lead cut-out set-point. Lead alternation to the next pump, will occur every 30-minutes. If demand cannot be satisfied by the lead pump, the lag pump(s) will start and stop based upon the lag cut-in and cut-out set-points. The HOA switch’s place the pump in the following modes: Hand-turns pump on to run continuous. Off- disables pump from running. Auto-places pump in the “ready mode” and will start and stop based on sequence described above.

Expandable systems include all control devices, operators, and programming for the maximum number of pumps (or plex) required. To expand the system: navigate to the “service screen” and enter the number of pumps.

Additional information and descriptions can be accessed through the HMI “service info” screen by pressing Sequence of Operations button.

REV	REVISION	DATE	ECN	NAME	CHKD
B-1	RELEASE TO PRODUCTION	09/01/11	22545	BFH	CHR
C-1	FORMAT UPDATE	03/01/13	PXEC0038	BFH	CHR

OPTIONAL:

208V/230V/380V/460V



CONFIDENTIAL DISCLOSURE:
This drawing is the property of the CAMPBELL GROUP of the SCOTT FETZER COMPANY and subject to return on demand. Its contents are confidential and must not be copied or submitted to outside parties for use or examination.

DRAWN BY	CHECKED BY	ENGINEERING APPROVAL
BFH	CHR	CHR
09/01/11	09/20/11	09/20/11

PANEL TYPE
BECKER DILLESS
3PH TRIPLEX PANEL DATA

DWG. TYPE
MISC

DWG. NO.
DATA TABLE

SHEET D-1	SIZE B
TRIPLEX PANEL DATA	

							<table><tr><td>REV</td><td>REVISION</td><td>DATE</td><td>ECN</td><td>NAME</td><td>CHKD</td></tr><tr><td>B-1</td><td>RELEASE TO PRODUCTION</td><td>09/01/11</td><td>22545</td><td>BFH</td><td>CHR</td></tr><tr><td>C-1</td><td>FORMAT UPDATE</td><td>03/04/13</td><td>PXEC0038</td><td>BFH</td><td>CHR</td></tr></table>						REV	REVISION	DATE	ECN	NAME	CHKD	B-1	RELEASE TO PRODUCTION	09/01/11	22545	BFH	CHR	C-1	FORMAT UPDATE	03/04/13	PXEC0038	BFH	CHR																																																						
REV	REVISION	DATE	ECN	NAME	CHKD																																																																															
B-1	RELEASE TO PRODUCTION	09/01/11	22545	BFH	CHR																																																																															
C-1	FORMAT UPDATE	03/04/13	PXEC0038	BFH	CHR																																																																															
TABLE 1	P/N	MOTOR FULL LOAD AMPS	TOTAL FULL LOAD AMPS	NON-TIME DELAY FUSE	TIME DELAY FUSE	INVERSE-TIME CIRCUIT BREAKER	NOTES: 1. RECOMMENDED TIGHTENING TORQUES FOR WIRE TERMINALS: 208-575 VOLT POWER 35 POUND INCHES 120 VOLT POWER AND CONTROL VOLTAGE 15 POUND INCHES 2. PANEL GROUND MUST BE CONNECTED TO EARTH GROUND 3. INSTALLER TO PROVIDE MAIN DISCONNECTING DEVICE FOR THIS ELECTRICAL ASSEMBLY. SHORT CIRCUIT PROTECTION IS RECOMMENDED, SEE TABLE 1. IF PROVIDING PANEL SHORT CIRCUIT PROTECTION USING CLASS J TIME DELAY FUSES, PANEL SCCR IS 65kA. OTHERWISE, PANEL SCCR IS 5kA. 4. ALL WIRES MUST BE LABELED ON BOTH ENDS 5. TRANSFORMER IS SIZED FOR LOADS SHOWN ON DRAWING ONLY. DO NOT CONNECT ANY OTHER DEVICES 6. △ -INDICATES A DRAWING WIRE CONNECTION TO ANOTHER PAGE. 7. SERVICE DISCONNECT USAGE - turn HOA switch to OFF position. Turn disconnect OF SAME UNIT to OFF position. Associated PLEX will be isolated for maintenance purposes. After completing maintenance, turn disconnect to ON position and return HOA switch to AUTO. This will return PLEX to normal operation.																																																																													
208V (3Ø)	22AJ	6	20	35	25	30																																																																														
	32AJ	8	26	45	35	40																																																																														
	52AJ	13	41	70	60	70																																																																														
	72AJ	19	59	100	80	90																																																																														
	A2AJ	25	77	150	100	125																																																																														
	F2AJ *	37.5	114.5	200	150	175																																																																														
230V (3Ø)	23AJ	5.2	17.6	30	25	30																																																																														
	33AJ	7.4	24.2	40	30	40																																																																														
	53AJ	12	38	70	50	60																																																																														
	73AJ	18	56	100	70	90																																																																														
	A3AJ	23	71	125	90	110																																																																														
	F3AJ *	35	107	200	150	175																																																																														
460V (3Ø)	24AJ	2.6	9.8	15	15	15																																																																														
	34AJ	3.7	13.1	25	20	20																																																																														
	54AJ	6	20	35	25	30																																																																														
	74AJ	9	29	50	40	45																																																																														
	A4AJ	11.5	36.5	60	45	60																																																																														
	F4AJ	17	53	90	70	80																																																																														
NOTE: P/N MAY INCLUDE SUFFIX AV							OPTIONAL: 208V/230V/460V POWEREX™ CONFIDENTIAL DISCLOSURE: This drawing is the property of the CAMPBELL GROUP of the SCOTT FETZER COMPANY and subject to return on demand. Its contents are confidential and must not be copied or submitted to outside parties for use or examination. <table><tr><td>DRAWN BY</td><td>CHECKED BY</td><td>ENGINEERING APPROVAL</td></tr><tr><td>BFH</td><td>CHR</td><td>CHR</td></tr><tr><td>09/01/11</td><td>09/20/11</td><td>09/20/11</td></tr></table> PANEL TYPE RIETSCHLE CLAW 3PH TRIPLEX PANEL DATA DWG. TYPE MISC DWG. NO. DATA TABLE <table><tr><td>SHEET</td><td>SIZE</td></tr><tr><td>D-1</td><td>B</td></tr></table> TRIPLEX PANEL DATA									DRAWN BY	CHECKED BY	ENGINEERING APPROVAL	BFH	CHR	CHR	09/01/11	09/20/11	09/20/11	SHEET	SIZE	D-1	B																																																								
DRAWN BY	CHECKED BY	ENGINEERING APPROVAL																																																																																		
BFH	CHR	CHR																																																																																		
09/01/11	09/20/11	09/20/11																																																																																		
SHEET	SIZE																																																																																			
D-1	B																																																																																			
																<table><tr><td colspan="4">CONTROL TRANSFORMERS - 500VA</td></tr><tr><td>REPLACEMENT</td><td>208</td><td>230</td><td>460 380</td><td>575</td></tr><tr><td>FUSE TYPE</td><td>VOLT</td><td>VOLT</td><td>VOLT</td><td>VOLT</td></tr><tr><td>FU1,2A FU1,2B</td><td>FNQR 6A</td><td>5A</td><td>5A</td><td>4A</td></tr><tr><td>FU3A,B</td><td>FNM 7A</td><td>7A</td><td>7A</td><td>7A</td></tr><tr><td colspan="4">SEE XFRMR FOR CONNECTIONS</td></tr></table> <table><tr><td colspan="4">WIRE TYPE TABLE</td></tr><tr><td>VOLTAGE</td><td>WIRE NUMBERS</td><td>GAUGE</td><td>COLOR</td></tr><tr><td>120VAC</td><td>001-599,1100+</td><td>16-18AWG</td><td>RED/BLK</td></tr><tr><td>0VAC</td><td>W</td><td>16-18AWG</td><td>WHT/BLK</td></tr><tr><td>24VDC</td><td>600-1099</td><td>16-18AWG</td><td>PURPLE</td></tr><tr><td>0VDC</td><td>601</td><td>16-18AWG</td><td>PURPLE</td></tr><tr><td>GND</td><td>-</td><td>VARIES</td><td>GREEN</td></tr><tr><td>CUSTOMER SUPPLY</td><td>01-99</td><td>16-18AWG</td><td>YELLOW</td></tr></table>									CONTROL TRANSFORMERS - 500VA				REPLACEMENT	208	230	460 380	575	FUSE TYPE	VOLT	VOLT	VOLT	VOLT	FU1,2A FU1,2B	FNQR 6A	5A	5A	4A	FU3A,B	FNM 7A	7A	7A	7A	SEE XFRMR FOR CONNECTIONS				WIRE TYPE TABLE				VOLTAGE	WIRE NUMBERS	GAUGE	COLOR	120VAC	001-599,1100+	16-18AWG	RED/BLK	0VAC	W	16-18AWG	WHT/BLK	24VDC	600-1099	16-18AWG	PURPLE	0VDC	601	16-18AWG	PURPLE	GND	-	VARIES	GREEN	CUSTOMER SUPPLY	01-99	16-18AWG	YELLOW
CONTROL TRANSFORMERS - 500VA																																																																																				
REPLACEMENT	208	230	460 380	575																																																																																
FUSE TYPE	VOLT	VOLT	VOLT	VOLT																																																																																
FU1,2A FU1,2B	FNQR 6A	5A	5A	4A																																																																																
FU3A,B	FNM 7A	7A	7A	7A																																																																																
SEE XFRMR FOR CONNECTIONS																																																																																				
WIRE TYPE TABLE																																																																																				
VOLTAGE	WIRE NUMBERS	GAUGE	COLOR																																																																																	
120VAC	001-599,1100+	16-18AWG	RED/BLK																																																																																	
0VAC	W	16-18AWG	WHT/BLK																																																																																	
24VDC	600-1099	16-18AWG	PURPLE																																																																																	
0VDC	601	16-18AWG	PURPLE																																																																																	
GND	-	VARIES	GREEN																																																																																	
CUSTOMER SUPPLY	01-99	16-18AWG	YELLOW																																																																																	
							SEQUENCE OF OPERATIONS During normal operation the PBMI controller will signal the Lead pump to run when vacuum drops to lead cut-in set-point and run for a 10-minute minimum period before stopping when the vacuum reaches the lead cut-out set-point. Lead alternation to the next pump, will occur every 30-minutes. If demand cannot be satisfied by the lead pump, the lag pump(s) will start and stop based upon the lag cut-in and cut-out set-points. The HOA switch’s place the pump in the following modes: Hand-turns pump on to run continuous. Off-disables pump from running. Auto-places pump in the “ready mode” and will start and stop based on sequence described above. Expandable systems include all control devices, operators, and programming for the maximum number of pumps (or plex) required. To expand the system: navigate to the “service screen” and enter the number of pumps. Additional information and descriptions can be accessed through the HMI “service info” screen by pressing Sequence of Operations button.																																																																													